


# DEVELOPMENT PLANS FOR VS SERVICES - WAREHOUSE

KANSAS CITY, MO 64133  
S29-T49N-R32W



## LEGEND

- 6IN - TREE AND DIAMETER
- 3IN - TREE AND DIAMETER
- 18" - TREE STUMP AND DIAMETER
- SN - SIGN
- - BUSH
- - MAIL BOX
- - POLE
- - GATE
- - POST / BOLLARD
- - FLAG POLE
- - FENCE
- - EDGE OF TREES
- - TELEPHONE RISER
- - UNDERGROUND TELEPHONE LINE
- - OVERHEAD TELEPHONE LINE
- - CABLE TV RISER
- - FIBER OPTICS INDICATOR SIGN
- - UNDERGROUND CABLE TV LINE
- - UNDERGROUND FIBER OPTIC CABLE
- - POWER POLE AND DEADMAN
- - LIGHT POLE
- - ELECTRIC TRANSFORMER
- - SCHOOL ZONE SIGNAL LIGHT
- - TRAFFIC CONTROL BOX
- - TRAFFIC SIGNAL LIGHT POLE
- - UNDERGROUND ELECTRIC LINE
- - OVERHEAD ELECTRIC LINE
- - GAS METER
- - GAS VALVE
- - GAS LINE
- - SANITARY SEWER MANHOLE
- - CLEANOUT
- - SANITARY SEWER LINE
- - INLET
- - STORM WATER MANHOLE
- - ROOF DRAIN
- - GRATE INLET
- - EXISTING STORM SEWER PIPE
- - SW - ROOF DRAIN LINE
- - PD - PERFORATE DRAIN PIPE
- - FIRE HYDRANT
- - WV - WATER VALVE
- - WATER METER
- - MONITORING WELL
- - WATER METER VAULT
- - WATER SPOOT
- - WATER LINE
- - FP - FIRE PROTECTION LINE
- - IRRIGATION CONTROL VALVE
- -100 - EXISTING MAJOR CONTOUR
- -101 - EXISTING MINOR CONTOUR

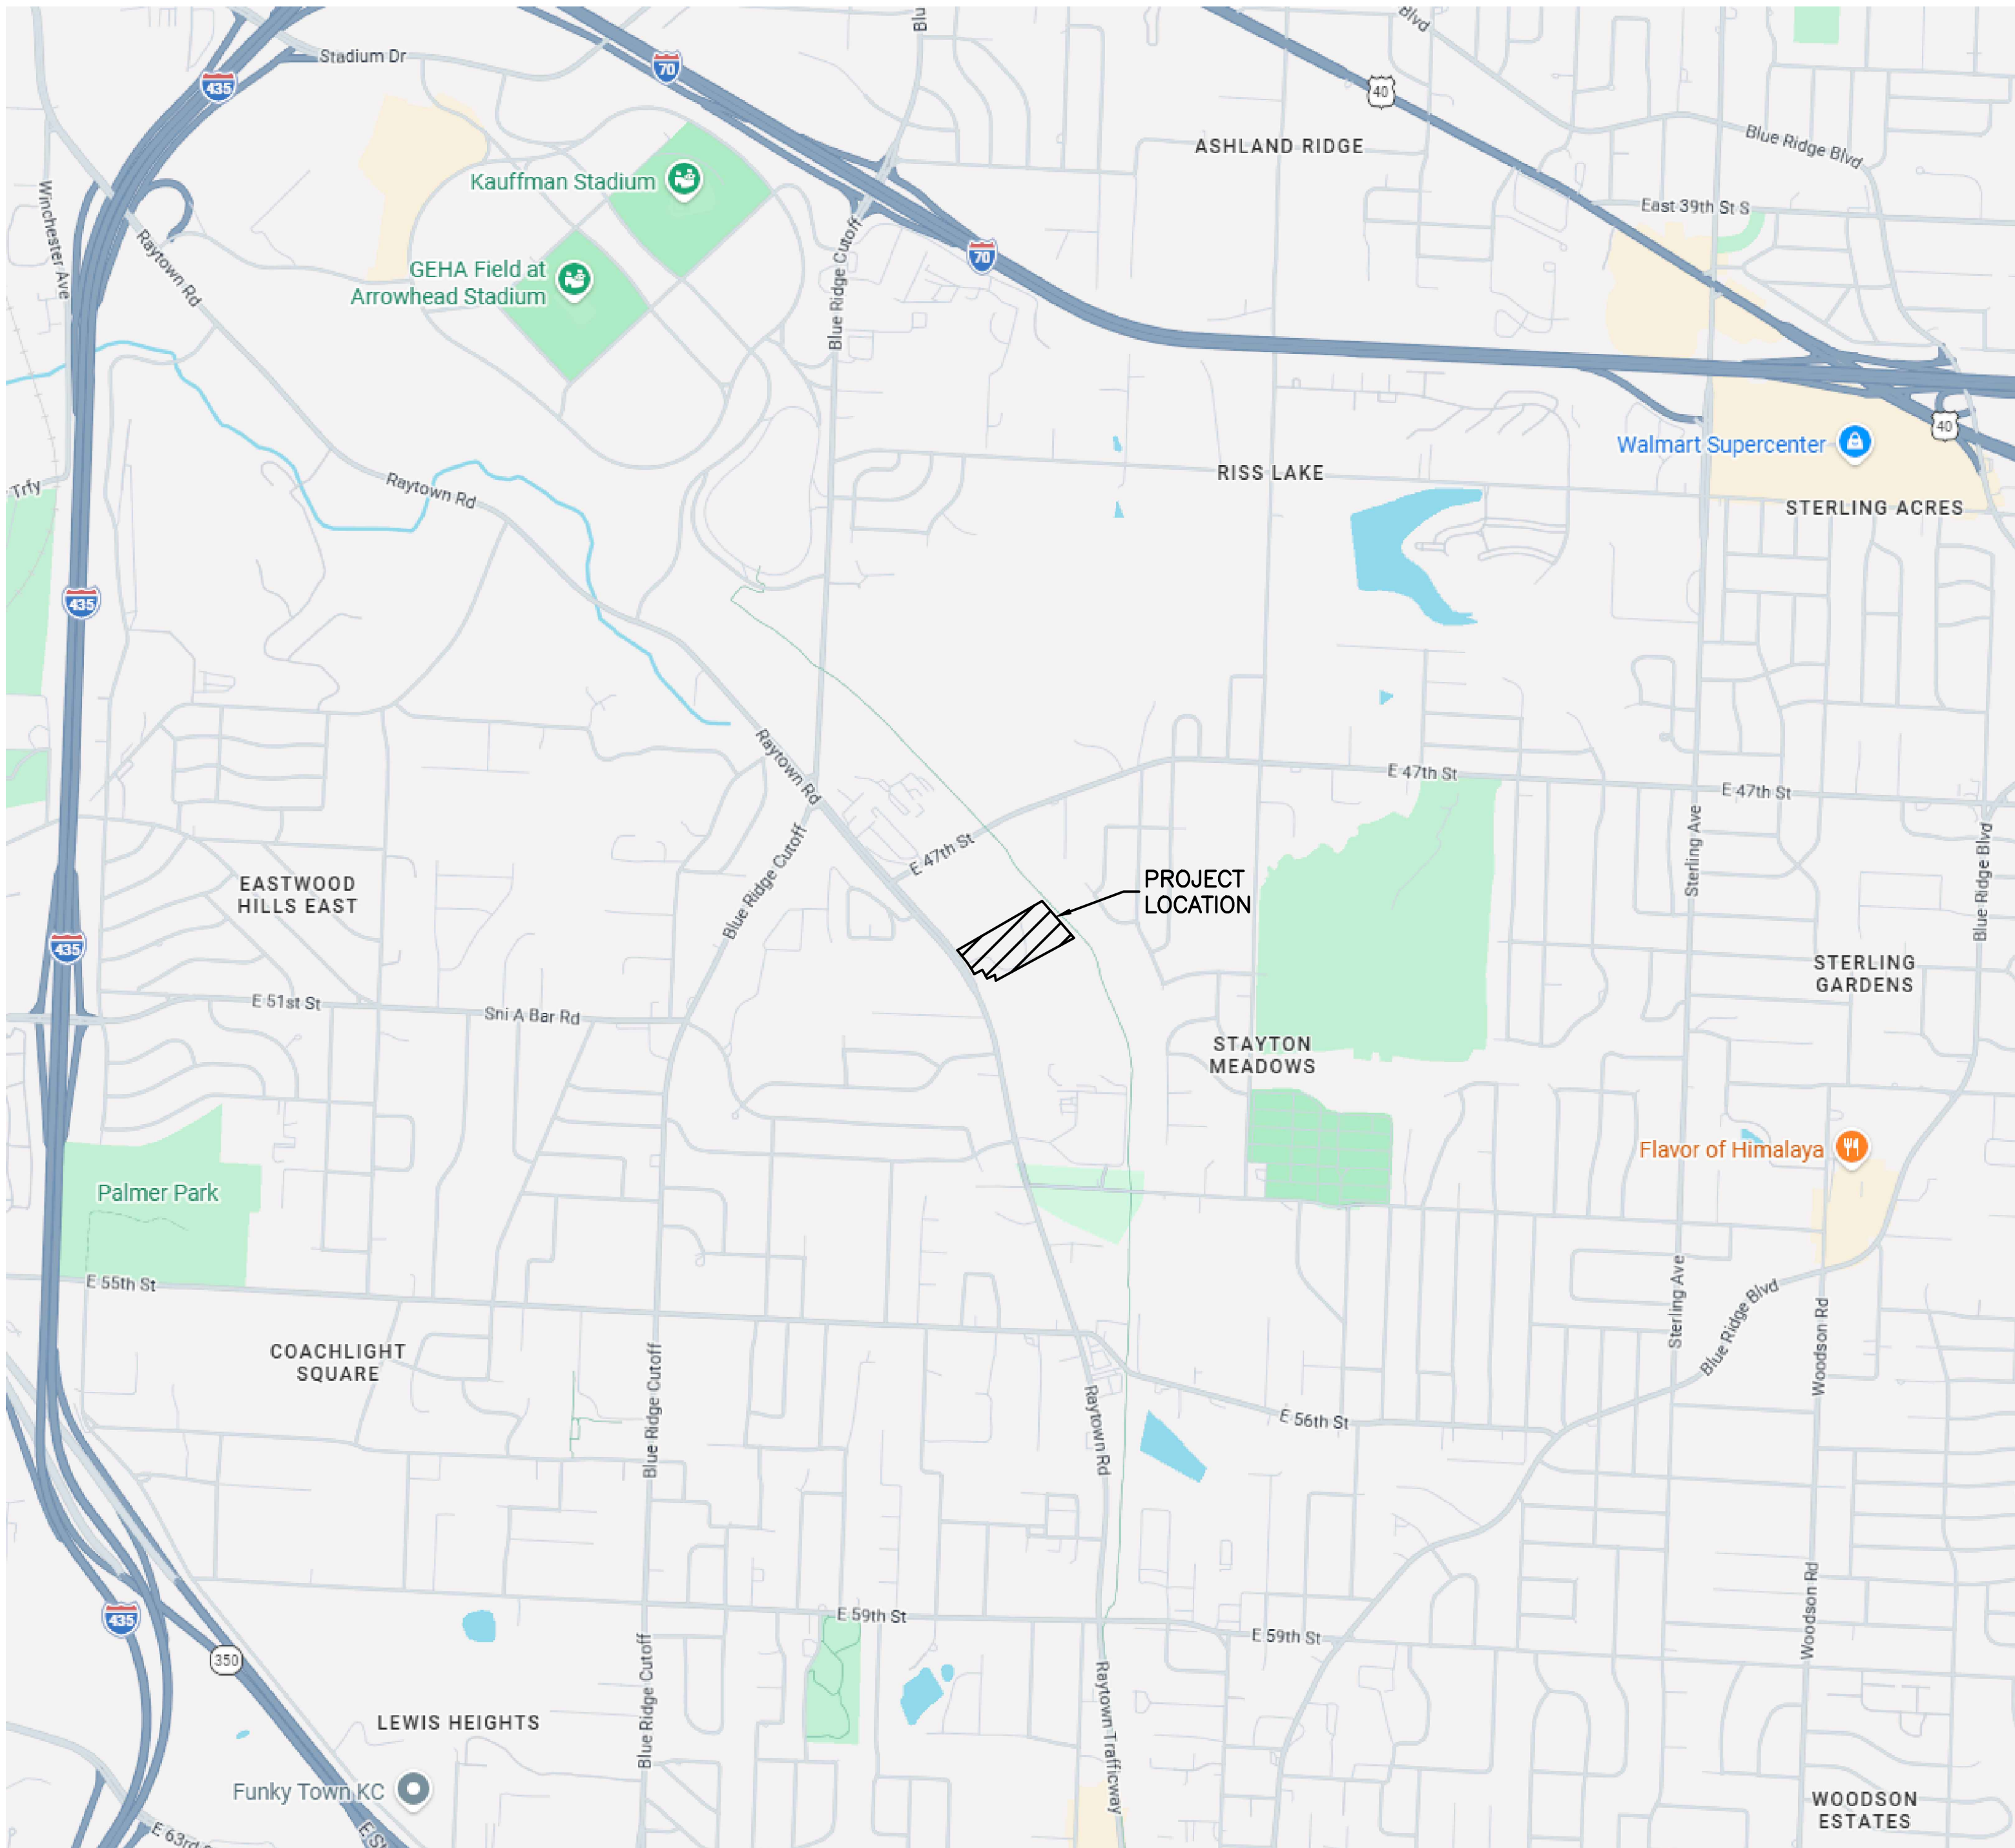

## LOCATION MAP

SCALE: NTS

## OWNER INFORMATION

111  
S.COM

## CONTACT INFORMATION

CIVIL ENGINEER/SURVEYOR/LANDSCAPE  
MKEC ENGINEERING  
11827 W. 112TH ST, SUITE 200  
OVERLAND PARK, KS 66210  
DAVID RILEY, P.E.  
DRATLEY@MKEC.COM  
913-317-9390

ARCHITECT  
COLLINS & WEBB  
307B SW MARKET ST  
LEE'S SUMMIT, MO 64063  
SEAN OWENS  
SOWENS@COLLINSANDBWEBB.COM  
816-249-2270

MEP ENGINEER  
ALVINE  
1201 CASS STREET  
OMAHA, NE 68102  
JOE KONEN  
JKONEN@ALVINE.COM  
402-346-7007

## Sheet List Table

| Sheet Number | Sheet Title                                       |
|--------------|---------------------------------------------------|
| G100         | COVER SHEET                                       |
| C100         | OVERALL SITE PLAN                                 |
| C101         | EXISTING CONDITIONS PLAN                          |
| C102         | SITE PLAN                                         |
| C103         | GRADING PLAN                                      |
| C104         | UTILITY PLAN                                      |
| L100         | LANDSCAPE PLAN                                    |
| L101         | LANDSCAPE NOTES                                   |
| A101         | FLOOR PLAN - 1ST FLOOR                            |
| A102         | REFLECTED CEILING PLAN AND DETAILS                |
| A104         | ROOF PLAN                                         |
| A201         | EXTERIOR ELEVATIONS                               |
| E001         | SITE PLAN - ELECTRICAL PHOTOMETRIC PLAN AND CALCS |

| SITE DATA                     | EXISTING | PROPOSED | DEVIATION REQUESTED? | APPROVED |
|-------------------------------|----------|----------|----------------------|----------|
| ZONING                        | M1-5     | M1-5     | NO                   |          |
| GROSS LAND AREA               |          |          |                      |          |
| IN SQUARE FEET                | 424,556  | 424,556  | NO                   |          |
| IN ACRES                      | 9.7      | 9.7      | NO                   |          |
| RIGHT-OF-WAY DEDICATION       |          |          |                      |          |
| IN SQUARE FEET                | 0        | 0        | NO                   |          |
| IN ACRES                      | 0        | 0        | NO                   |          |
| NET LAND AREA                 |          |          |                      |          |
| IN SQUARE FEET                | 424,556  | 424,556  | NO                   |          |
| IN ACRES                      | 9.7      | 9.7      | NO                   |          |
| PROP. BUILDING AREA (SQ. FT.) | -        | 12,000   |                      |          |
| TOTAL BUILDING AREA (SQ. FT.) | 0        | 12,000   | NO                   |          |
| FLOOR AREA RATIO              | 0.000    | 0.028    | NO                   |          |
| RESIDENTIAL USE INFO          |          |          |                      |          |
| TOTAL DWELLING UNITS          | 0        | 0        |                      |          |
| DETACHED HOUSE                | 0        | 0        |                      |          |
| ZERO LOT LINE HOUSE           | 0        | 0        |                      |          |
| COTTAGE HOUSE                 | 0        | 0        |                      |          |
| SEMI-ATTACHED HOUSE           | 0        | 0        |                      |          |
| TOWNHOUSE                     | 0        | 0        |                      |          |
| TWO-UNIT HOUSE                | 0        | 0        |                      |          |
| MULTI-UNIT HOUSE              | 0        | 0        |                      |          |
| COLONNADE                     | 0        | 0        |                      |          |
| MULTIPLEX                     | 0        | 0        |                      |          |
| MULTI-UNIT BUILDING           | 0        | 0        |                      |          |
| TOTAL LOTS                    | 1        | 1        |                      |          |
| RESIDENTIAL                   | 0        | 0        |                      |          |
| PUBLIC/CIVIC                  | 0        | 0        |                      |          |
| COMMERCIAL                    | 0        | 0        |                      |          |
| INDUSTRIAL                    | 1        | 1        |                      |          |
| OTHER                         | 0        | 0        |                      |          |

## LEGAL DESCRIPTION

ALL THAT PART OF THE SOUTH HALF OF SECTION 29, TOWNSHIP 49, RANGE 32 (BEING A PORTION OF TRACT 15 OF THE COMMISSIONERS PLAT OF THE PENDLETON LANDS, ALSO KNOWN AS "PLAT OF PENDLETON LANDS") IN KANSAS CITY, JACKSON COUNTY, MISSOURI, DESCRIBED AS FOLLOWS: BEGINNING AT A POINT SEVEN HUNDRED AND FOUR AND 23/100 FEET EAST OF THE NORTHWEST CORNER OF THE SOUTHWEST QUARTER OF THE SOUTHEAST QUARTER OF SECTION 29, IN TOWNSHIP 49, RANGE 32, SAID POINT BEING ON THE WEST LINE OF THE RIGHT-OF-WAY OF THE KANSAS CITY ROCK ISLAND RAILWAY COMPANY; THENCE IN SOUTHEASTERLY DIRECTION WITH SAID RIGHT-OF-WAY OF SAID RAILWAY COMPANY FOUR HUNDRED AND NINETY ONE AND 25/100 FEET; THENCE SOUTH 57 DEGREES 37 MINUTES WEST ONE THOUSAND EIGHTY-SEVEN AND 3/10 FEET; THENCE NORTH 40 DEGREES 45 MINUTES WEST TWO HUNDRED FIFTY-FOUR AND 5/10 FEET; THENCE NORTH 48 DEGREES 30 MINUTES WEST TWO HUNDRED THIRTY EIGHT AND 2/10 FEET; THENCE NORTH 57 DEGREES 37 MINUTES EAST ONE THOUSAND EIGHTY NINE AND 5/10 FEET TO PLACE OF BEGINNING, EXCEPTING THEREFROM THE FOLLOWING:

- (1) THAT PART CONVEYED BY DEED RECORDED SEPTEMBER 28, 1929 AS DOCUMENT NO. 270232 IN BOOK 533 AT PAGE 374 TO JAMES E. FUNKHOUSER AND ANNE L. FUNKHOUSER, HUSBAND AND WIFE.
- (2) THAT PART CONVEYED BY DEED RECORDED MAY 3, 1946 AS DOCUMENT NO. 514406 IN BOOK 765 AT PAGE 248 TO CHARLES L. PETERS AND ANNE F. PETERS, HUSBAND AND WIFE.
- (3) THAT PART PLATTED AS LOT 1, BOEHM FARM AS SHOWN ON PLAT RECORDED JUNE 19, 1950 AS DOCUMENT NO. 565416 IN PLAT BOOK 14 AT PAGE 19.
- (4) THAT PART TAKEN FOR RAYTOWN ROAD AND RELOCATED RAYTOWN ROAD BY THE DOCUMENT RECORDED OCTOBER 26, 1929 AS DOCUMENT NO. 271771 IN BOOK 555 AT PAGE 68 AND BY THE DOCUMENT RECORDED JANUARY 22, 1971 AS DOCUMENT NO. 1-77106 IN BOOK 1-232 AT PAGE 70.



**City Plan Commission**  
**Recommends Approval with Conditions**

of Case No. CD-CPC-2026-00023 on 04-15-2026

*Sara Cooperanu*

Sara Cooperanu, FAICP  
Secretary of the City Plan Commission

**VS SERVICES - WAREHOUSE**

5019 RAYTOWN RD  
KANSAS CITY, MISSOURI 64133

COPYRIGHT © BY  
COLLINS WEBB  
ARCHITECTURE, LLC

REVISION DATES:

JAMES D. RILEY, P.E. #201102780

PROFESSIONAL SEAL


**G100**

ISSUE DATE: 23 FEBRUARY 2026  
COLLINS WEBB #: 26029

COVER SHEET

DEVELOPMENT PLAN SUBMITTAL

P:\PROJECTS\2025\202010866\_VS\_5019 Raytown Road\00 CAD\SHST\05 Civil\CMO Development Plans\202010866\_CS101-DP.dwg 3/27/2026 5:02 PM

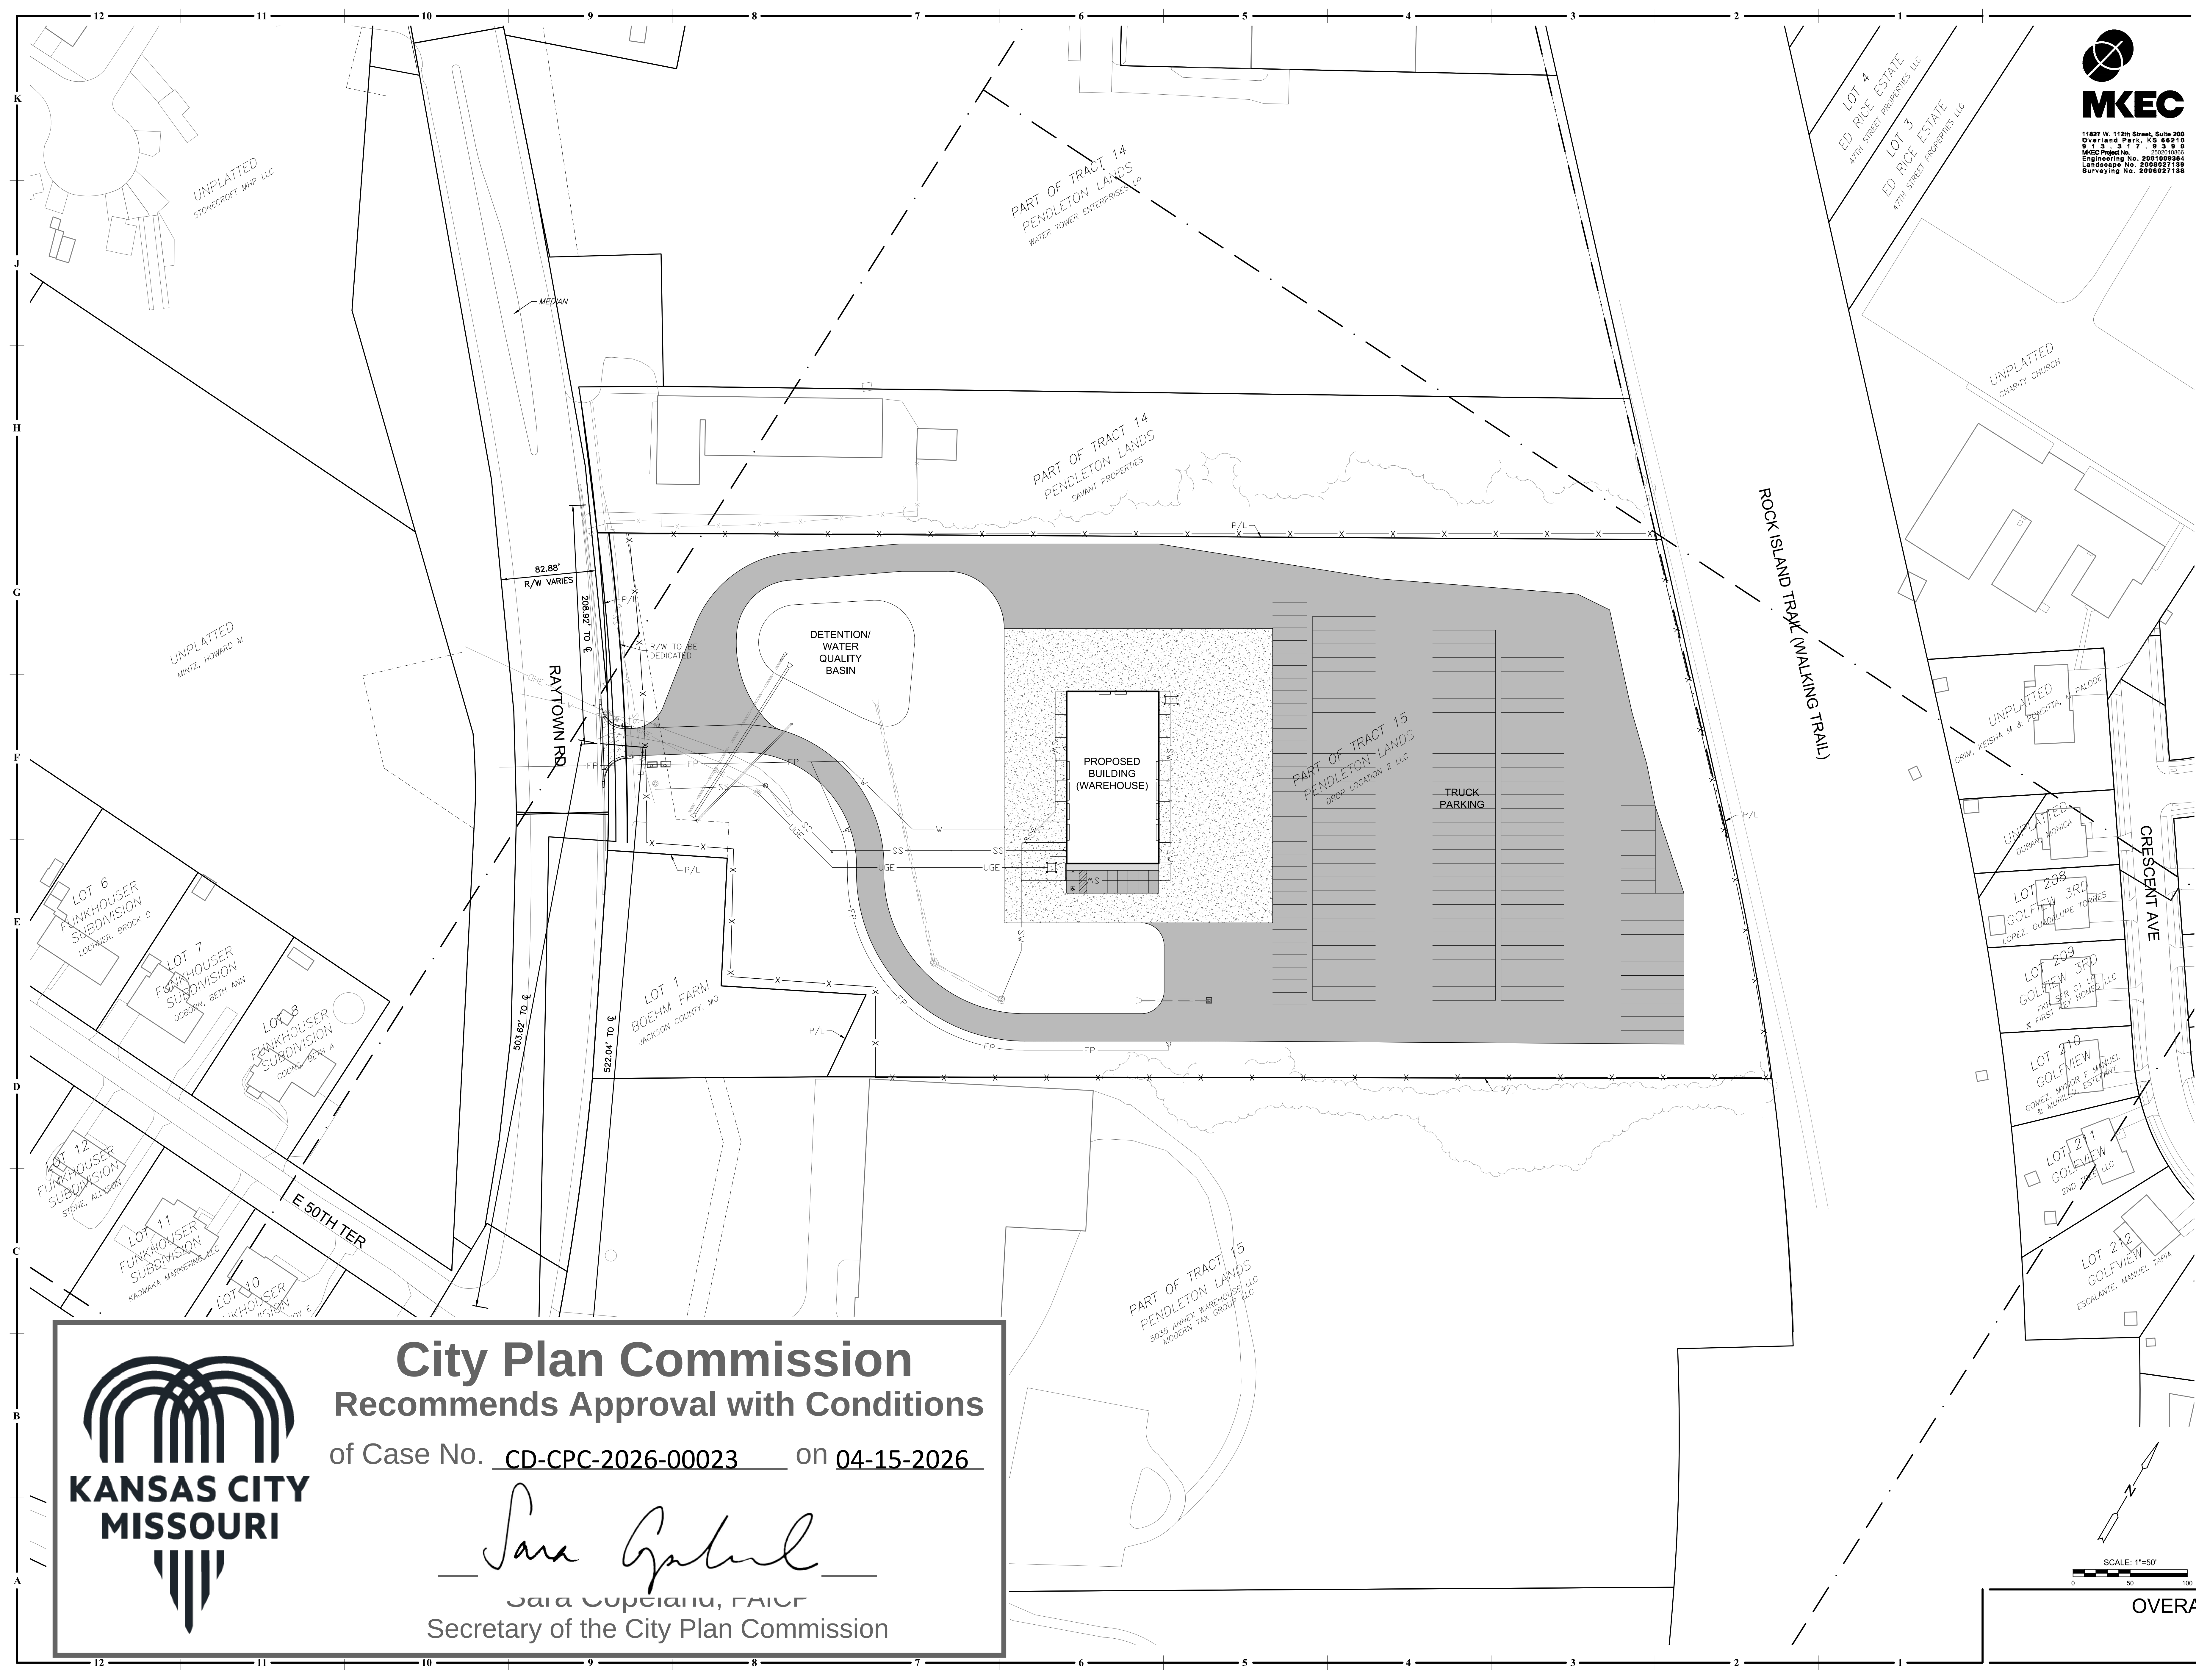

# VS SERVICES - WAREHOUSE

5019 RAYTOWN RD  
KANSAS CITY, MISSOURI 64133

COPYRIGHT © BY  
COLLINS WEBB  
ARCHITECTURE, LLC  
REVISION DATES:


JAMES D. RAITLEY, P.E. #2011027880

PROFESSIONAL SEAL  
**C100**  
ISSUE DATE: 23 FEBRUARY 2026  
COLLINS WEBB #: 28029

DEVELOPMENT PLAN SUBMITTAL




**City Plan Commission**  
**Recommends Approval with Conditions**  
of Case No. CD-CPC-2026-00023 on 04-15-2026  
*Sara Copeland*  
Sara Copeland, FAICP  
Secretary of the City Plan Commission

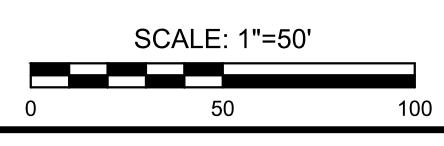

OVERALL SITE PLAN

P:\PROJECTS\2025\202010866\_VS\_5019 Raytown Road\00 CAD\SHS\05 Civil\KCMO Development Plans\2020866\_C-101-DP.dwg

2/20/2026 5:16 PM

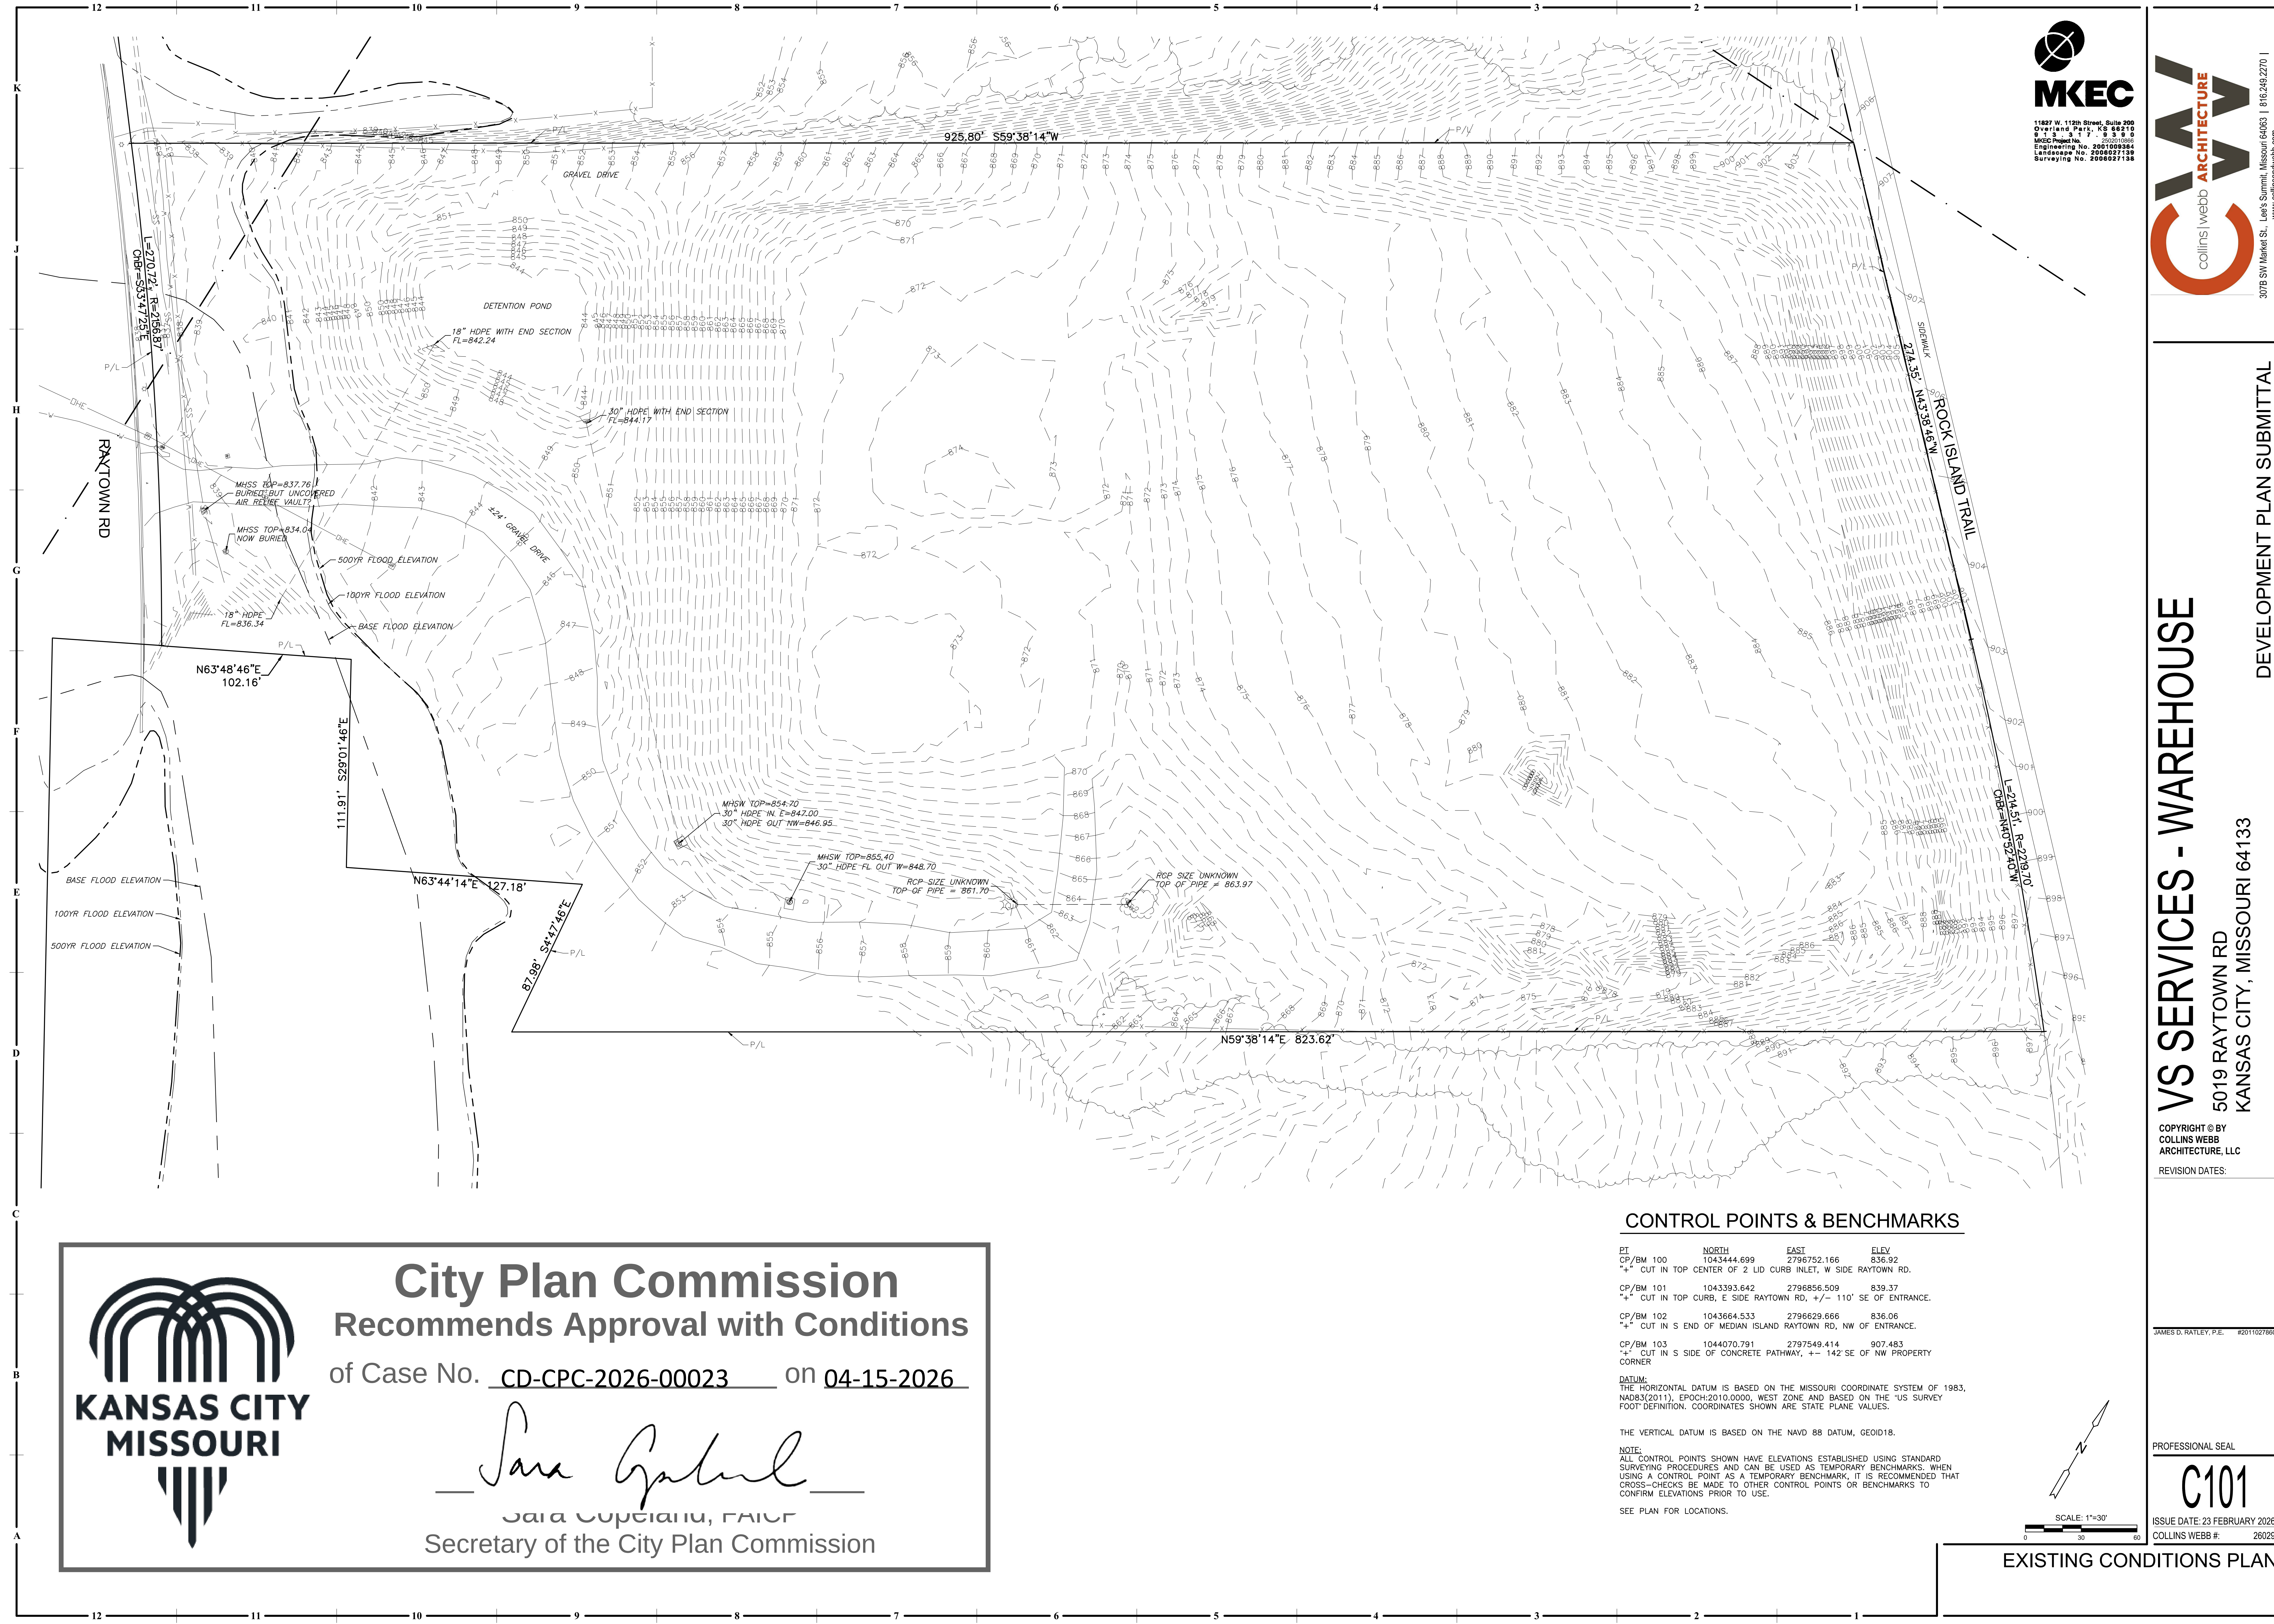

**MKEC**  
11227 W. 112th Street, Suite 200  
Overland Park, KS 66210  
913.241.1100  
MKEC is a member of the  
Engineering No. 2007009364  
Landmark No. 2008027138  
Surveying No. 2008027138

**collins webb ARCHITECTURE**  
3076 SW Market St., Lee's Summit, Missouri 64063 | 816.249.2270 |  
www.collinswebb.com

**VS SERVICES - WAREHOUSE**  
5019 RAYTOWN RD  
KANSAS CITY, MISSOURI 64133  
DEVELOPMENT PLAN SUBMITTAL  
COPYRIGHT © BY  
COLLINS WEBB  
ARCHITECTURE, LLC  
REVISION DATES:

JAMES D. RAYLEY, P.E. #2011027880

PROFESSIONAL SEAL  
**C101**  
ISSUE DATE: 23 FEBRUARY 2026  
COLLINS WEBB # 26029

**City Plan Commission**  
Recommends Approval with Conditions

of Case No. CD-CPC-2026-00023 on 04-15-2026

*Sara Copeland*

Sara Copeland, FAICP  
Secretary of the City Plan Commission



**CONTROL POINTS & BENCHMARKS**


| PT                                                                      | NORTH       | EAST        | ELEV    |
|-------------------------------------------------------------------------|-------------|-------------|---------|
| CP/BM 100                                                               | 1043444.699 | 2796752.166 | 836.92  |
| +/- CUT IN TOP CENTER OF 2 LID CURB INLET, W SIDE RAYTOWN RD.           |             |             |         |
| CP/BM 101                                                               | 1043393.642 | 2796856.509 | 839.37  |
| +/- CUT IN TOP CURB, E SIDE RAYTOWN RD, +/- 110' SE OF ENTRANCE.        |             |             |         |
| CP/BM 102                                                               | 1043664.533 | 2796629.666 | 836.06  |
| +/- CUT IN S END OF MEDIAN ISLAND RAYTOWN RD, NW OF ENTRANCE.           |             |             |         |
| CP/BM 103                                                               | 1044070.791 | 2797549.414 | 907.483 |
| +/- CUT IN S SIDE OF CONCRETE PATHWAY, +/- 142 SE OF NW PROPERTY CORNER |             |             |         |

**DATUM:**  
THE HORIZONTAL DATUM IS BASED ON THE MISSOURI COORDINATE SYSTEM OF 1983, NAD83(2011), EPOCH:2010.0000, WEST ZONE AND BASED ON THE "US SURVEY FOOT DEFINITION. COORDINATES SHOWN ARE STATE PLANE VALUES.

THE VERTICAL DATUM IS BASED ON THE NAVD 88 DATUM, GEOID18.

**NOTE:**  
ALL CONTROL POINTS SHOWN HAVE ELEVATIONS ESTABLISHED USING STANDARD SURVEYING PROCEDURES AND CAN BE USED AS TEMPORARY BENCHMARKS. WHEN USING A CONTROL POINT AS A TEMPORARY BENCHMARK, IT IS RECOMMENDED THAT CROSS-CHECKS BE MADE TO OTHER CONTROL POINTS OR BENCHMARKS TO CONFIRM ELEVATIONS PRIOR TO USE.


SEE PLAN FOR LOCATIONS.

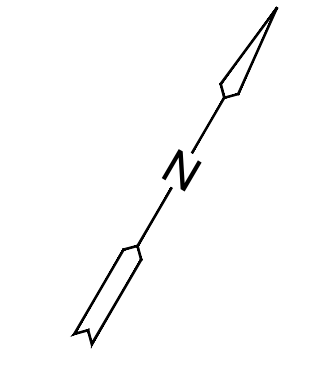

SCALE: 1"=30'  
0 30 60

**EXISTING CONDITIONS PLAN**

P:\PROJECTS\2025\202502010686\_VS\_5019 Raytown Road\00 CAD\SH\T505 Civil\KCMO Development Plans\250686\_CS102-DF.dwg 3/27/2026 5:02 PM

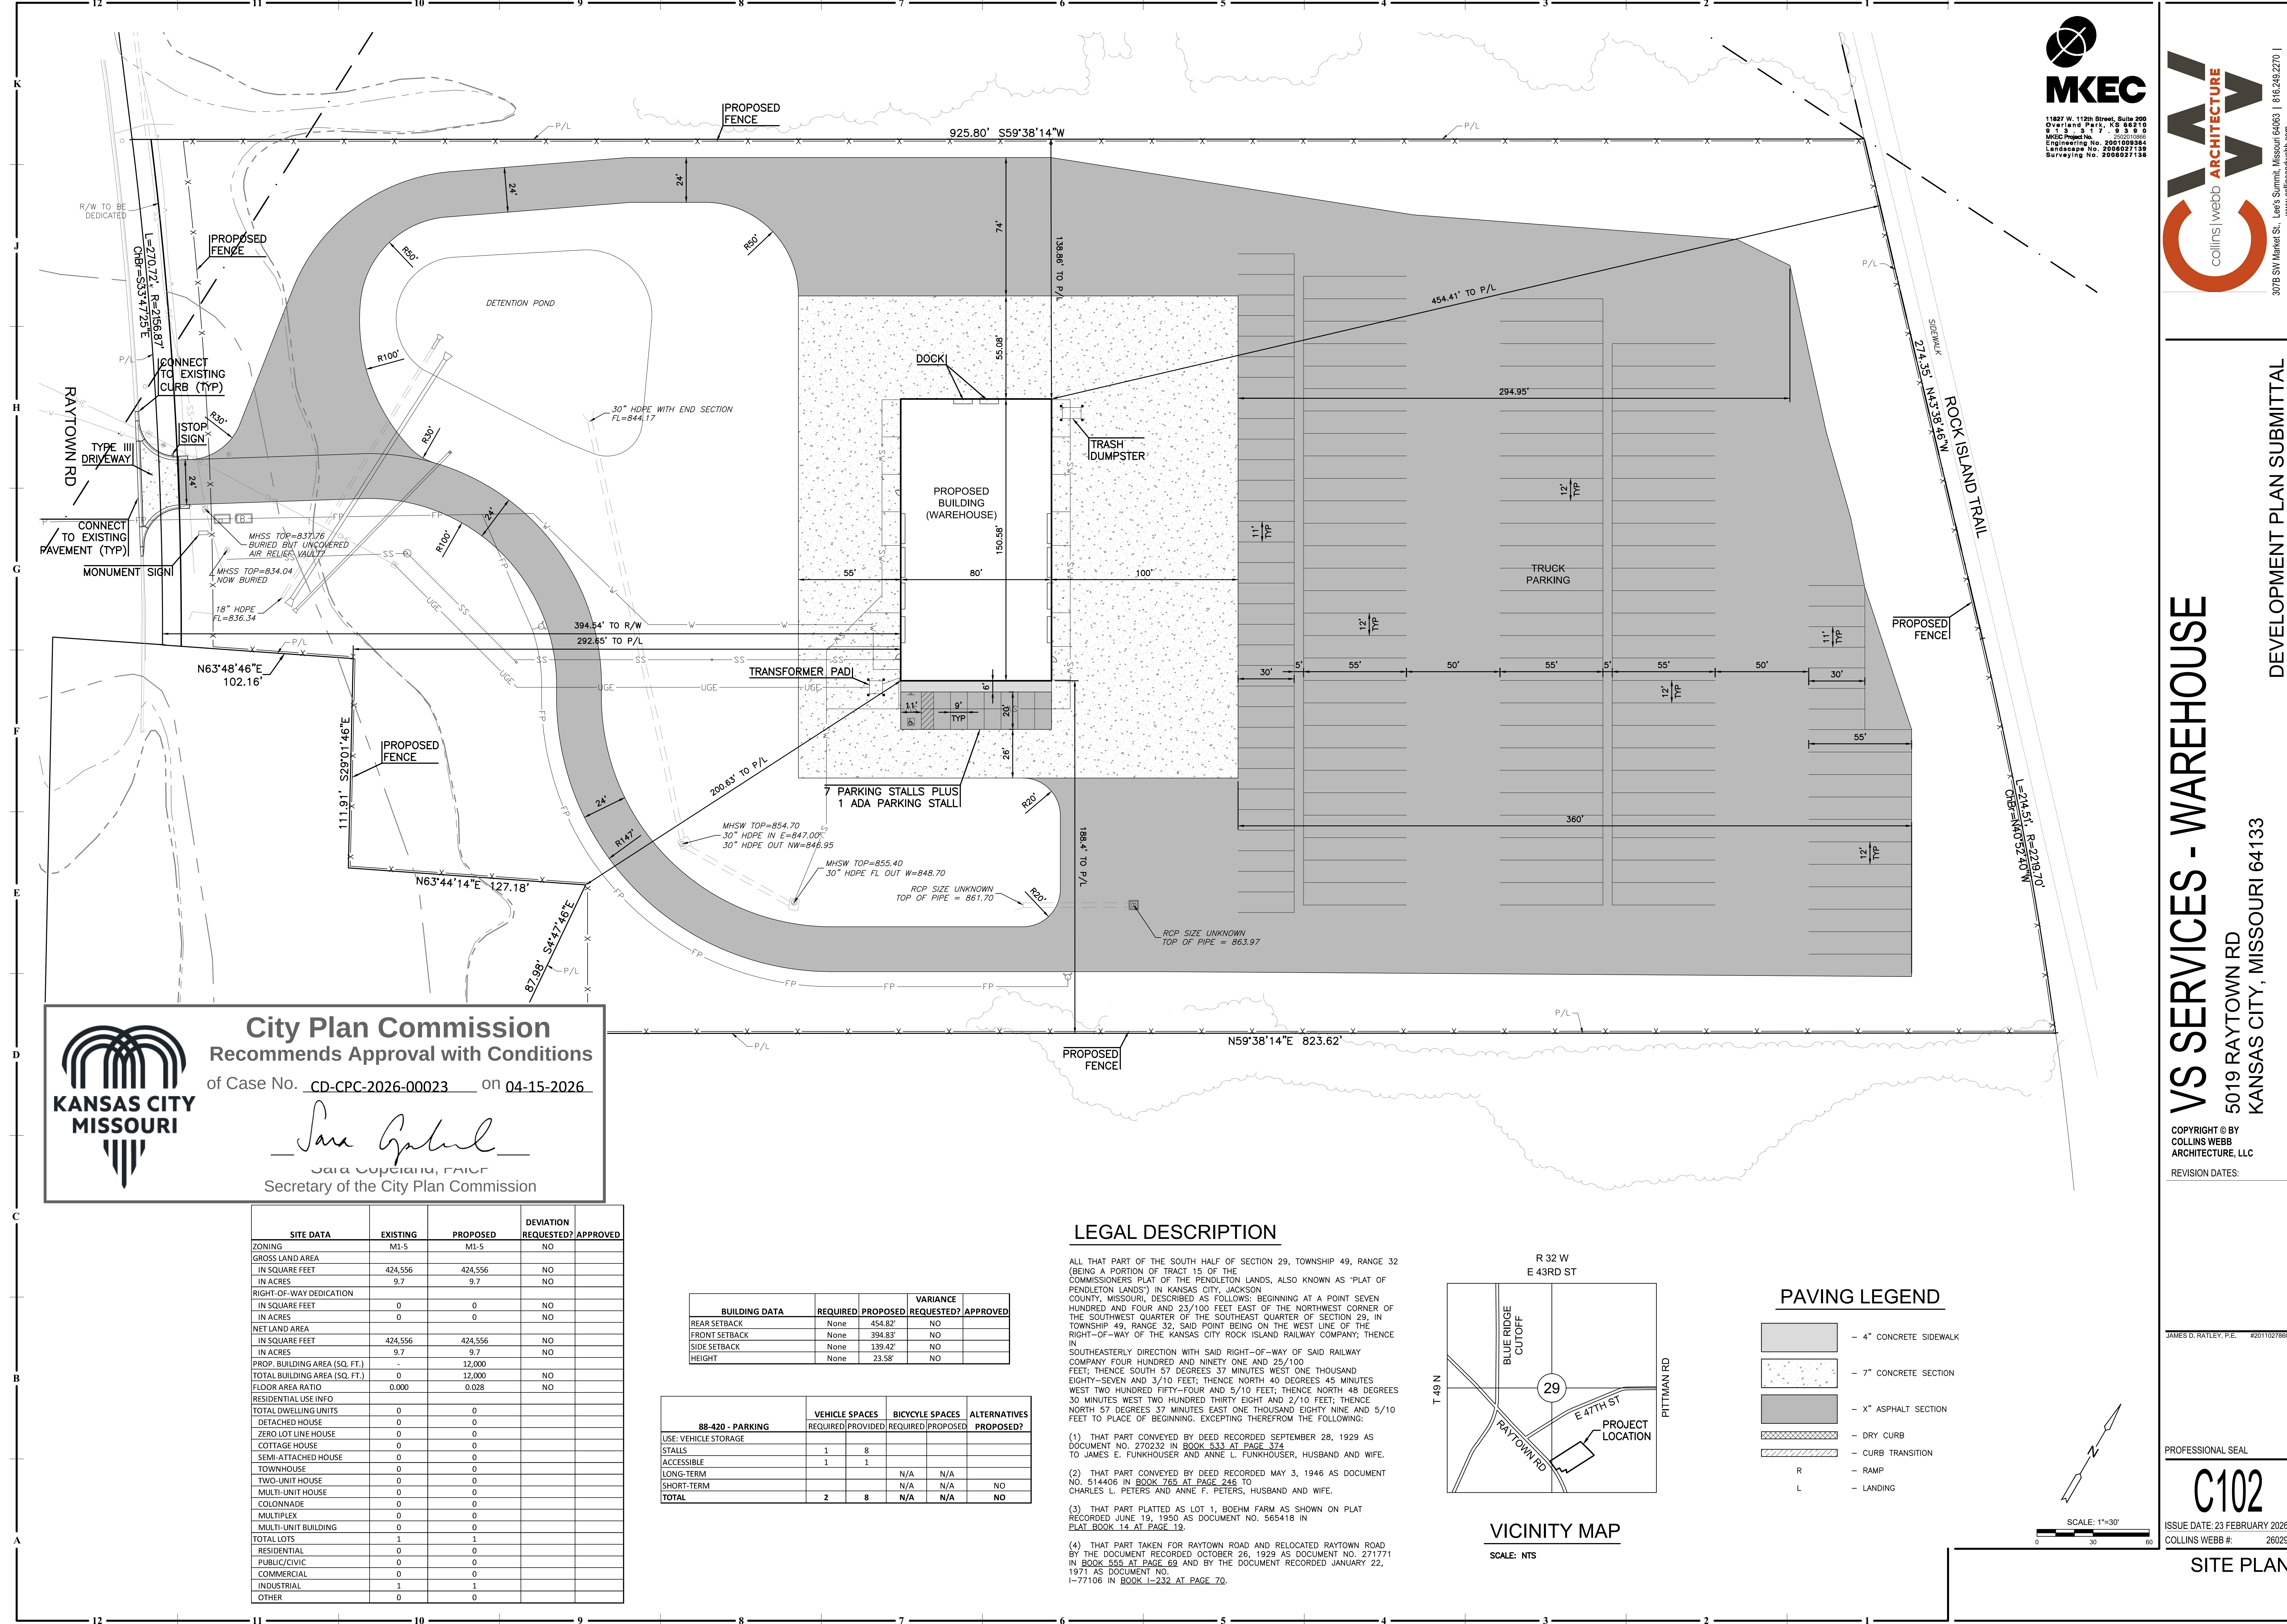

City Plan Commission  
Recommends Approval with Conditions

of Case No. CD-CPC-2026-00023 on 04-15-2026

*Sara Gabriel*  
Sara Cupciani, FAICP  
Secretary of the City Plan Commission

| SITE DATA                     | EXISTING | PROPOSED | DEVIATION REQUESTED? | APPROVED |
|-------------------------------|----------|----------|----------------------|----------|
| ZONING                        | M1-5     | M1-5     | NO                   |          |
| GROSS LAND AREA               |          |          |                      |          |
| IN SQUARE FEET                | 424,556  | 424,556  | NO                   |          |
| IN ACRES                      | 9.7      | 9.7      | NO                   |          |
| RIGHT-OF-WAY DEDICATION       |          |          |                      |          |
| IN SQUARE FEET                | 0        | 0        | NO                   |          |
| IN ACRES                      | 0        | 0        | NO                   |          |
| NET LAND AREA                 |          |          |                      |          |
| IN SQUARE FEET                | 424,556  | 424,556  | NO                   |          |
| IN ACRES                      | 9.7      | 9.7      | NO                   |          |
| PROP. BUILDING AREA (SQ. FT.) | -        | 12,000   |                      |          |
| TOTAL BUILDING AREA (SQ. FT.) | 0        | 12,000   | NO                   |          |
| FLOOR AREA RATIO              | 0.000    | 0.028    | NO                   |          |
| RESIDENTIAL USE INFO          |          |          |                      |          |
| TOTAL DWELLING UNITS          | 0        | 0        |                      |          |
| DETACHED HOUSE                | 0        | 0        |                      |          |
| ZERO LOT LINE HOUSE           | 0        | 0        |                      |          |
| COTTAGE HOUSE                 | 0        | 0        |                      |          |
| SEMI-ATTACHED HOUSE           | 0        | 0        |                      |          |
| TOWNHOUSE                     | 0        | 0        |                      |          |
| TWO-UNIT HOUSE                | 0        | 0        |                      |          |
| MULTI-UNIT HOUSE              | 0        | 0        |                      |          |
| COLONNADE                     | 0        | 0        |                      |          |
| MULTI-PLEX                    | 0        | 0        |                      |          |
| MULTI-UNIT BUILDING           | 0        | 0        |                      |          |
| TOTAL LOTS                    | 1        | 1        |                      |          |
| RESIDENTIAL                   |          |          |                      |          |
| PUBLIC/CIVIC                  | 0        | 0        |                      |          |
| COMMERCIAL                    | 0        | 0        |                      |          |
| INDUSTRIAL                    | 1        | 1        |                      |          |
| OTHER                         | 0        | 0        |                      |          |


| BUILDING DATA | REQUIRED | PROPOSED | VARIANCE REQUESTED? | APPROVED |
|---------------|----------|----------|---------------------|----------|
| REAR SETBACK  | None     | 454.82'  | NO                  |          |
| FRONT SETBACK | None     | 394.83'  | NO                  |          |
| SIDE SETBACK  | None     | 139.42'  | NO                  |          |
| HEIGHT        | None     | 23.58'   | NO                  |          |

| 88-420 - PARKING     | VEHICLE SPACES |          | BICYCLE SPACES |          | ALTERNATIVES |
|----------------------|----------------|----------|----------------|----------|--------------|
|                      | REQUIRED       | PROVIDED | REQUIRED       | PROPOSED | PROPOSED?    |
| USE: VEHICLE STORAGE |                |          |                |          |              |
| STALLS               | 1              | 8        |                |          |              |
| ACCESSIBLE           | 1              | 1        |                |          |              |
| LONG-TERM            |                |          | N/A            | N/A      |              |
| SHORT-TERM           |                |          | N/A            | N/A      | NO           |
| TOTAL                | 2              | 8        | N/A            | N/A      | NO           |

LEGAL DESCRIPTION

ALL THAT PART OF THE SOUTH HALF OF SECTION 29, TOWNSHIP 49, RANGE 32 (BEING A PORTION OF TRACT 15 OF THE COMMISSIONERS PLAT OF THE PENDLETON LANDS, ALSO KNOWN AS "PLAT OF PENDLETON LANDS") IN KANSAS CITY, JACKSON COUNTY, MISSOURI, DESCRIBED AS FOLLOWS: BEGINNING AT A POINT SEVEN HUNDRED AND FOUR AND 23/100 FEET EAST OF THE NORTHWEST CORNER OF THE SOUTHWEST QUARTER OF THE SOUTHEAST QUARTER OF SECTION 29, IN TOWNSHIP 49, RANGE 32, SAID POINT BEING ON THE WEST LINE OF THE RIGHT-OF-WAY OF THE KANSAS CITY ROCK ISLAND RAILWAY COMPANY; THENCE IN SOUTHEASTERLY DIRECTION WITH SAID RIGHT-OF-WAY OF SAID RAILWAY COMPANY FOUR HUNDRED AND NINETY ONE AND 25/100 FEET; THENCE SOUTH 57 DEGREES 37 MINUTES WEST ONE THOUSAND EIGHTY-SEVEN AND 3/10 FEET; THENCE NORTH 40 DEGREES 45 MINUTES WEST TWO HUNDRED FIFTY-FOUR AND 5/10 FEET; THENCE NORTH 48 DEGREES 30 MINUTES WEST TWO HUNDRED THIRTY EIGHT AND 2/10 FEET; THENCE NORTH 57 DEGREES 37 MINUTES EAST ONE THOUSAND EIGHTY NINE AND 5/10 FEET TO PLACE OF BEGINNING, EXCEPTING THEREFROM THE FOLLOWING:

- THAT PART CONVEYED BY DEED RECORDED SEPTEMBER 28, 1929 AS DOCUMENT NO. 270232 IN BOOK 533 AT PAGE 374 TO JAMES E. FUNKHOUSER AND ANNE L. FUNKHOUSER, HUSBAND AND WIFE.
- THAT PART CONVEYED BY DEED RECORDED MAY 3, 1946 AS DOCUMENT NO. 514406 IN BOOK 765 AT PAGE 246 TO CHARLES L. PETERS AND ANNE F. PETERS, HUSBAND AND WIFE.
- THAT PART PLATTED AS LOT 1, BOEHM FARM AS SHOWN ON PLAT RECORDED JUNE 19, 1950 AS DOCUMENT NO. 565418 IN PLAT BOOK 14 AT PAGE 19.
- THAT PART TAKEN FOR RAYTOWN ROAD AND RELOCATED RAYTOWN ROAD BY THE DOCUMENT RECORDED OCTOBER 26, 1929 AS DOCUMENT NO. 271771 IN BOOK 555 AT PAGE 69 AND BY THE DOCUMENT RECORDED JANUARY 22, 1971 AS DOCUMENT NO. 1-77106 IN BOOK 1-232 AT PAGE 70.

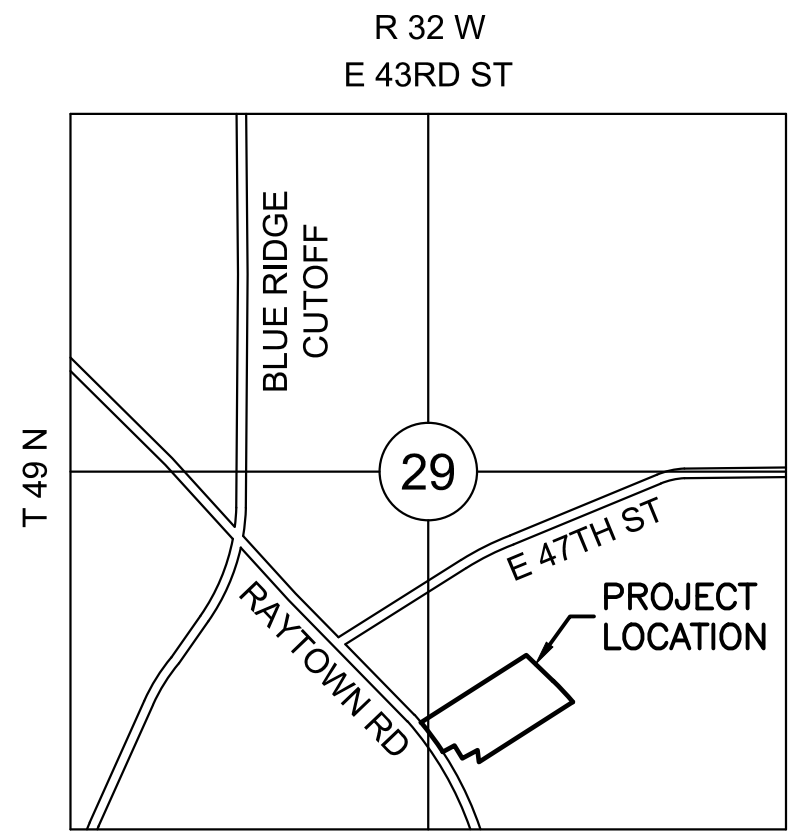

VICINITY MAP

SCALE: NTS

PAVING LEGEND

- 4" CONCRETE SIDEWALK
- 7" CONCRETE SECTION
- X" ASPHALT SECTION
- DRY CURB
- CURB TRANSITION
- RAMP
- LANDING

SCALE: 1"=30'

VS SERVICES - WAREHOUSE

5019 RAYTOWN RD  
KANSAS CITY, MISSOURI 64133

COPYRIGHT © BY  
COLLINS WEBB  
ARCHITECTURE, LLC

REVISION DATES:

PROFESSIONAL SEAL

C102

ISSUE DATE: 23 FEBRUARY 2026  
COLLINS WEBB #: 26029

SITE PLAN




11227 W. 112th Street, Suite 200  
Overland Park, KS 66210  
913.551.1122  
MKEC-Professional  
Engineering No. 2007009364  
Landscape No. 2008027139  
Surveying No. 2008027138



3076 SW Market St., Lee's Summit, Missouri 64063 | 816.249.2270 | www.collinswebb.com

DEVELOPMENT PLAN SUBMITTAL

P:\PROJECTS\2025\202010866\_VS\_5019 Raytown Road\00 CAD\SHS\05 Civil\KCMO Development Plans\250866\_CG101-DP.dwg 3/27/2026 5:03 PM

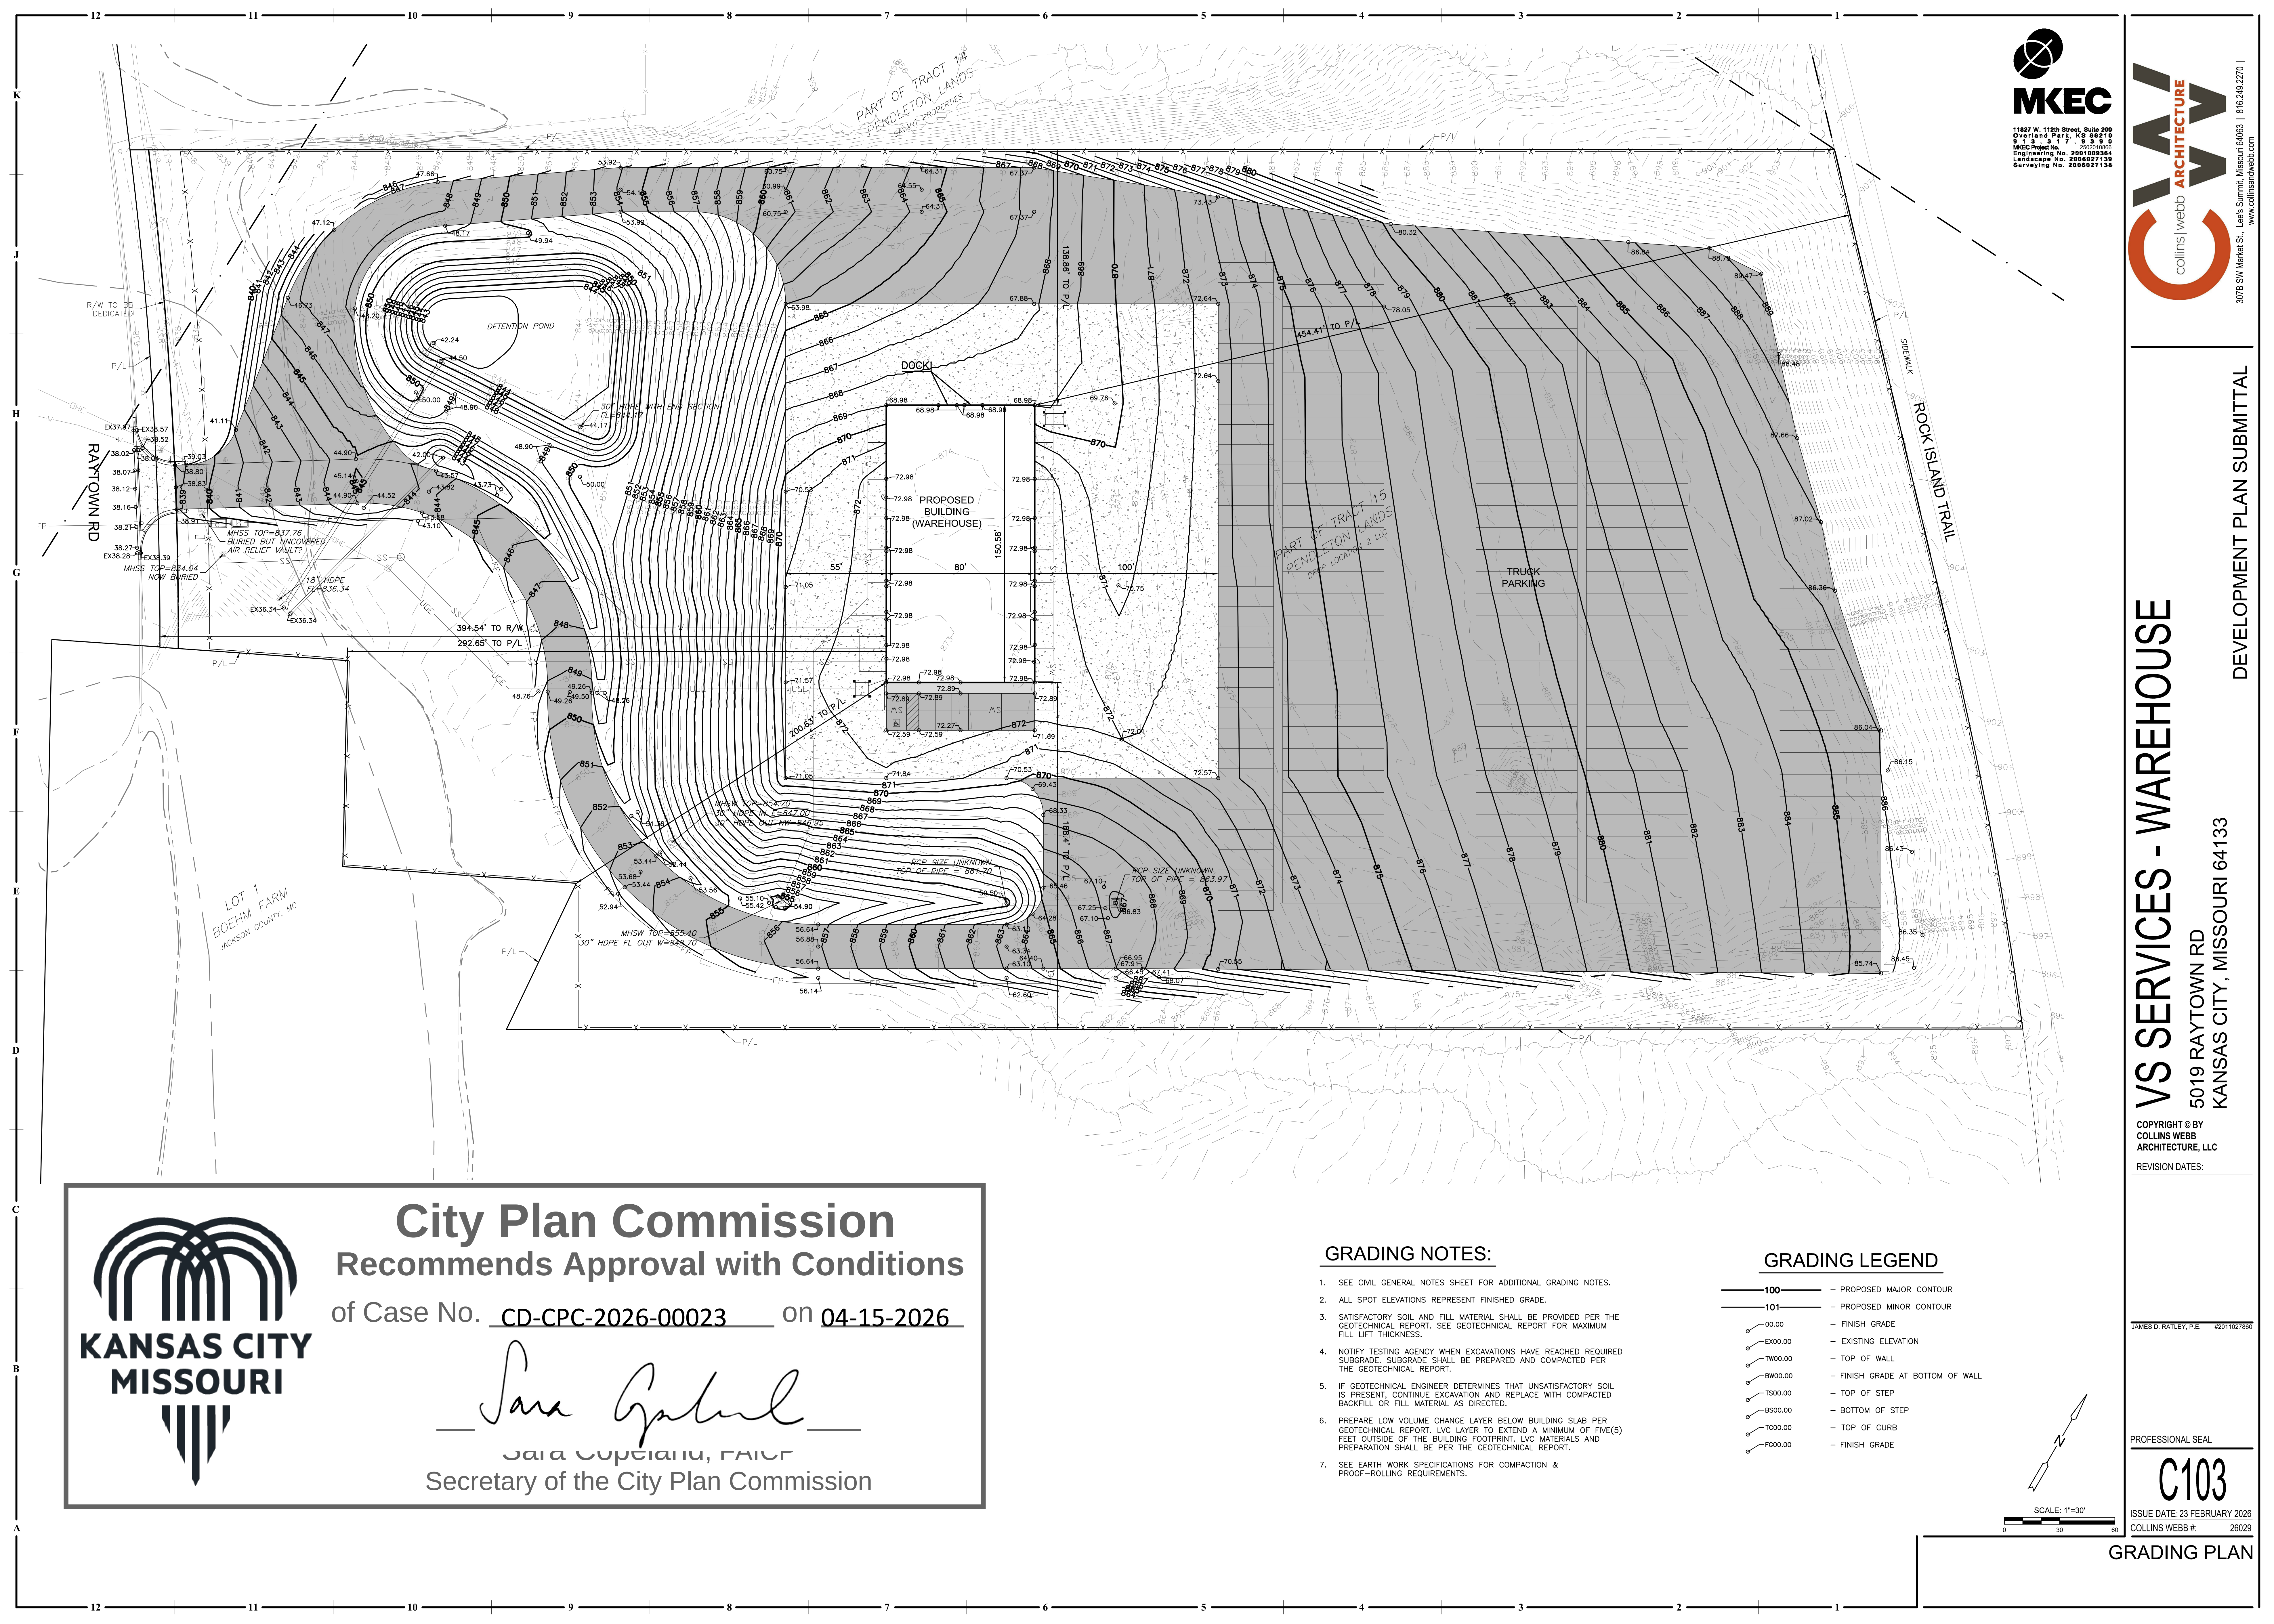

**MKEC**  
11827 W. 112th Street, Suite 200  
Overland Park, KS 66210  
913.551.1100  
MKEC Project No. 2007009364  
Engineering No. 2007009364  
Landmark No. 2008027138  
Surveying No. 2008027138

**collins webb ARCHITECTURE**  
3076 SW Market St., Lee's Summit, Missouri 64083 | 816.249.2270 | www.collinswebb.com

**VS SERVICES - WAREHOUSE**  
5019 RAYTOWN RD  
KANSAS CITY, MISSOURI 64133

DEVELOPMENT PLAN SUBMITTAL  
COPYRIGHT © BY  
COLLINS WEBB  
ARCHITECTURE, LLC  
REVISION DATES:

JAMES D. RAYLEY, P.E. #2011027880  
PROFESSIONAL SEAL  
**C103**  
ISSUE DATE: 23 FEBRUARY 2026  
COLLINS WEBB #: 28029  
**GRADING PLAN**




**City Plan Commission**  
**Recommends Approval with Conditions**  
of Case No. CD-CPC-2026-00023 on 04-15-2026  
*Sara Copeland*  
Sara Copeland, FAICP  
Secretary of the City Plan Commission

**GRADING NOTES:**


1. SEE CIVIL GENERAL NOTES SHEET FOR ADDITIONAL GRADING NOTES.
2. ALL SPOT ELEVATIONS REPRESENT FINISHED GRADE.
3. SATISFACTORY SOIL AND FILL MATERIAL SHALL BE PROVIDED PER THE GEOTECHNICAL REPORT. SEE GEOTECHNICAL REPORT FOR MAXIMUM FILL LIFT THICKNESS.
4. NOTIFY TESTING AGENCY WHEN EXCAVATIONS HAVE REACHED REQUIRED SUBGRADE. SUBGRADE SHALL BE PREPARED AND COMPACTED PER THE GEOTECHNICAL REPORT.
5. IF GEOTECHNICAL ENGINEER DETERMINES THAT UNSATISFACTORY SOIL IS PRESENT, CONTINUE EXCAVATION AND REPLACE WITH COMPACTED BACKFILL OR FILL MATERIAL AS DIRECTED.
6. PREPARE LOW VOLUME CHANGE LAYER BELOW BUILDING SLAB PER GEOTECHNICAL REPORT. LVC LAYER TO EXTEND A MINIMUM OF FIVE(5) FEET OUTSIDE OF THE BUILDING FOOTPRINT. LVC MATERIALS AND PREPARATION SHALL BE PER THE GEOTECHNICAL REPORT.
7. SEE EARTH WORK SPECIFICATIONS FOR COMPACTION & PROOF-ROLLING REQUIREMENTS.

**GRADING LEGEND**

- |         |                                  |
|---------|----------------------------------|
| 100     | - PROPOSED MAJOR CONTOUR         |
| 101     | - PROPOSED MINOR CONTOUR         |
| 00.00   | - FINISH GRADE                   |
| EX00.00 | - EXISTING ELEVATION             |
| TW00.00 | - TOP OF WALL                    |
| BW00.00 | - FINISH GRADE AT BOTTOM OF WALL |
| TS00.00 | - TOP OF STEP                    |
| BS00.00 | - BOTTOM OF STEP                 |
| TC00.00 | - TOP OF CURB                    |
| FG00.00 | - FINISH GRADE                   |

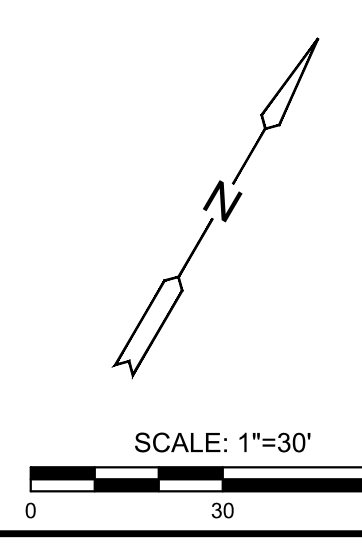

P:\PROJECTS\2025\202010866\_VS\_5019 Raytown Road\00 CAD\SHS\05 Civil\CMO Development Plans\2020866\_CU101-DP.dwg 3/27/2026 4:59 PM

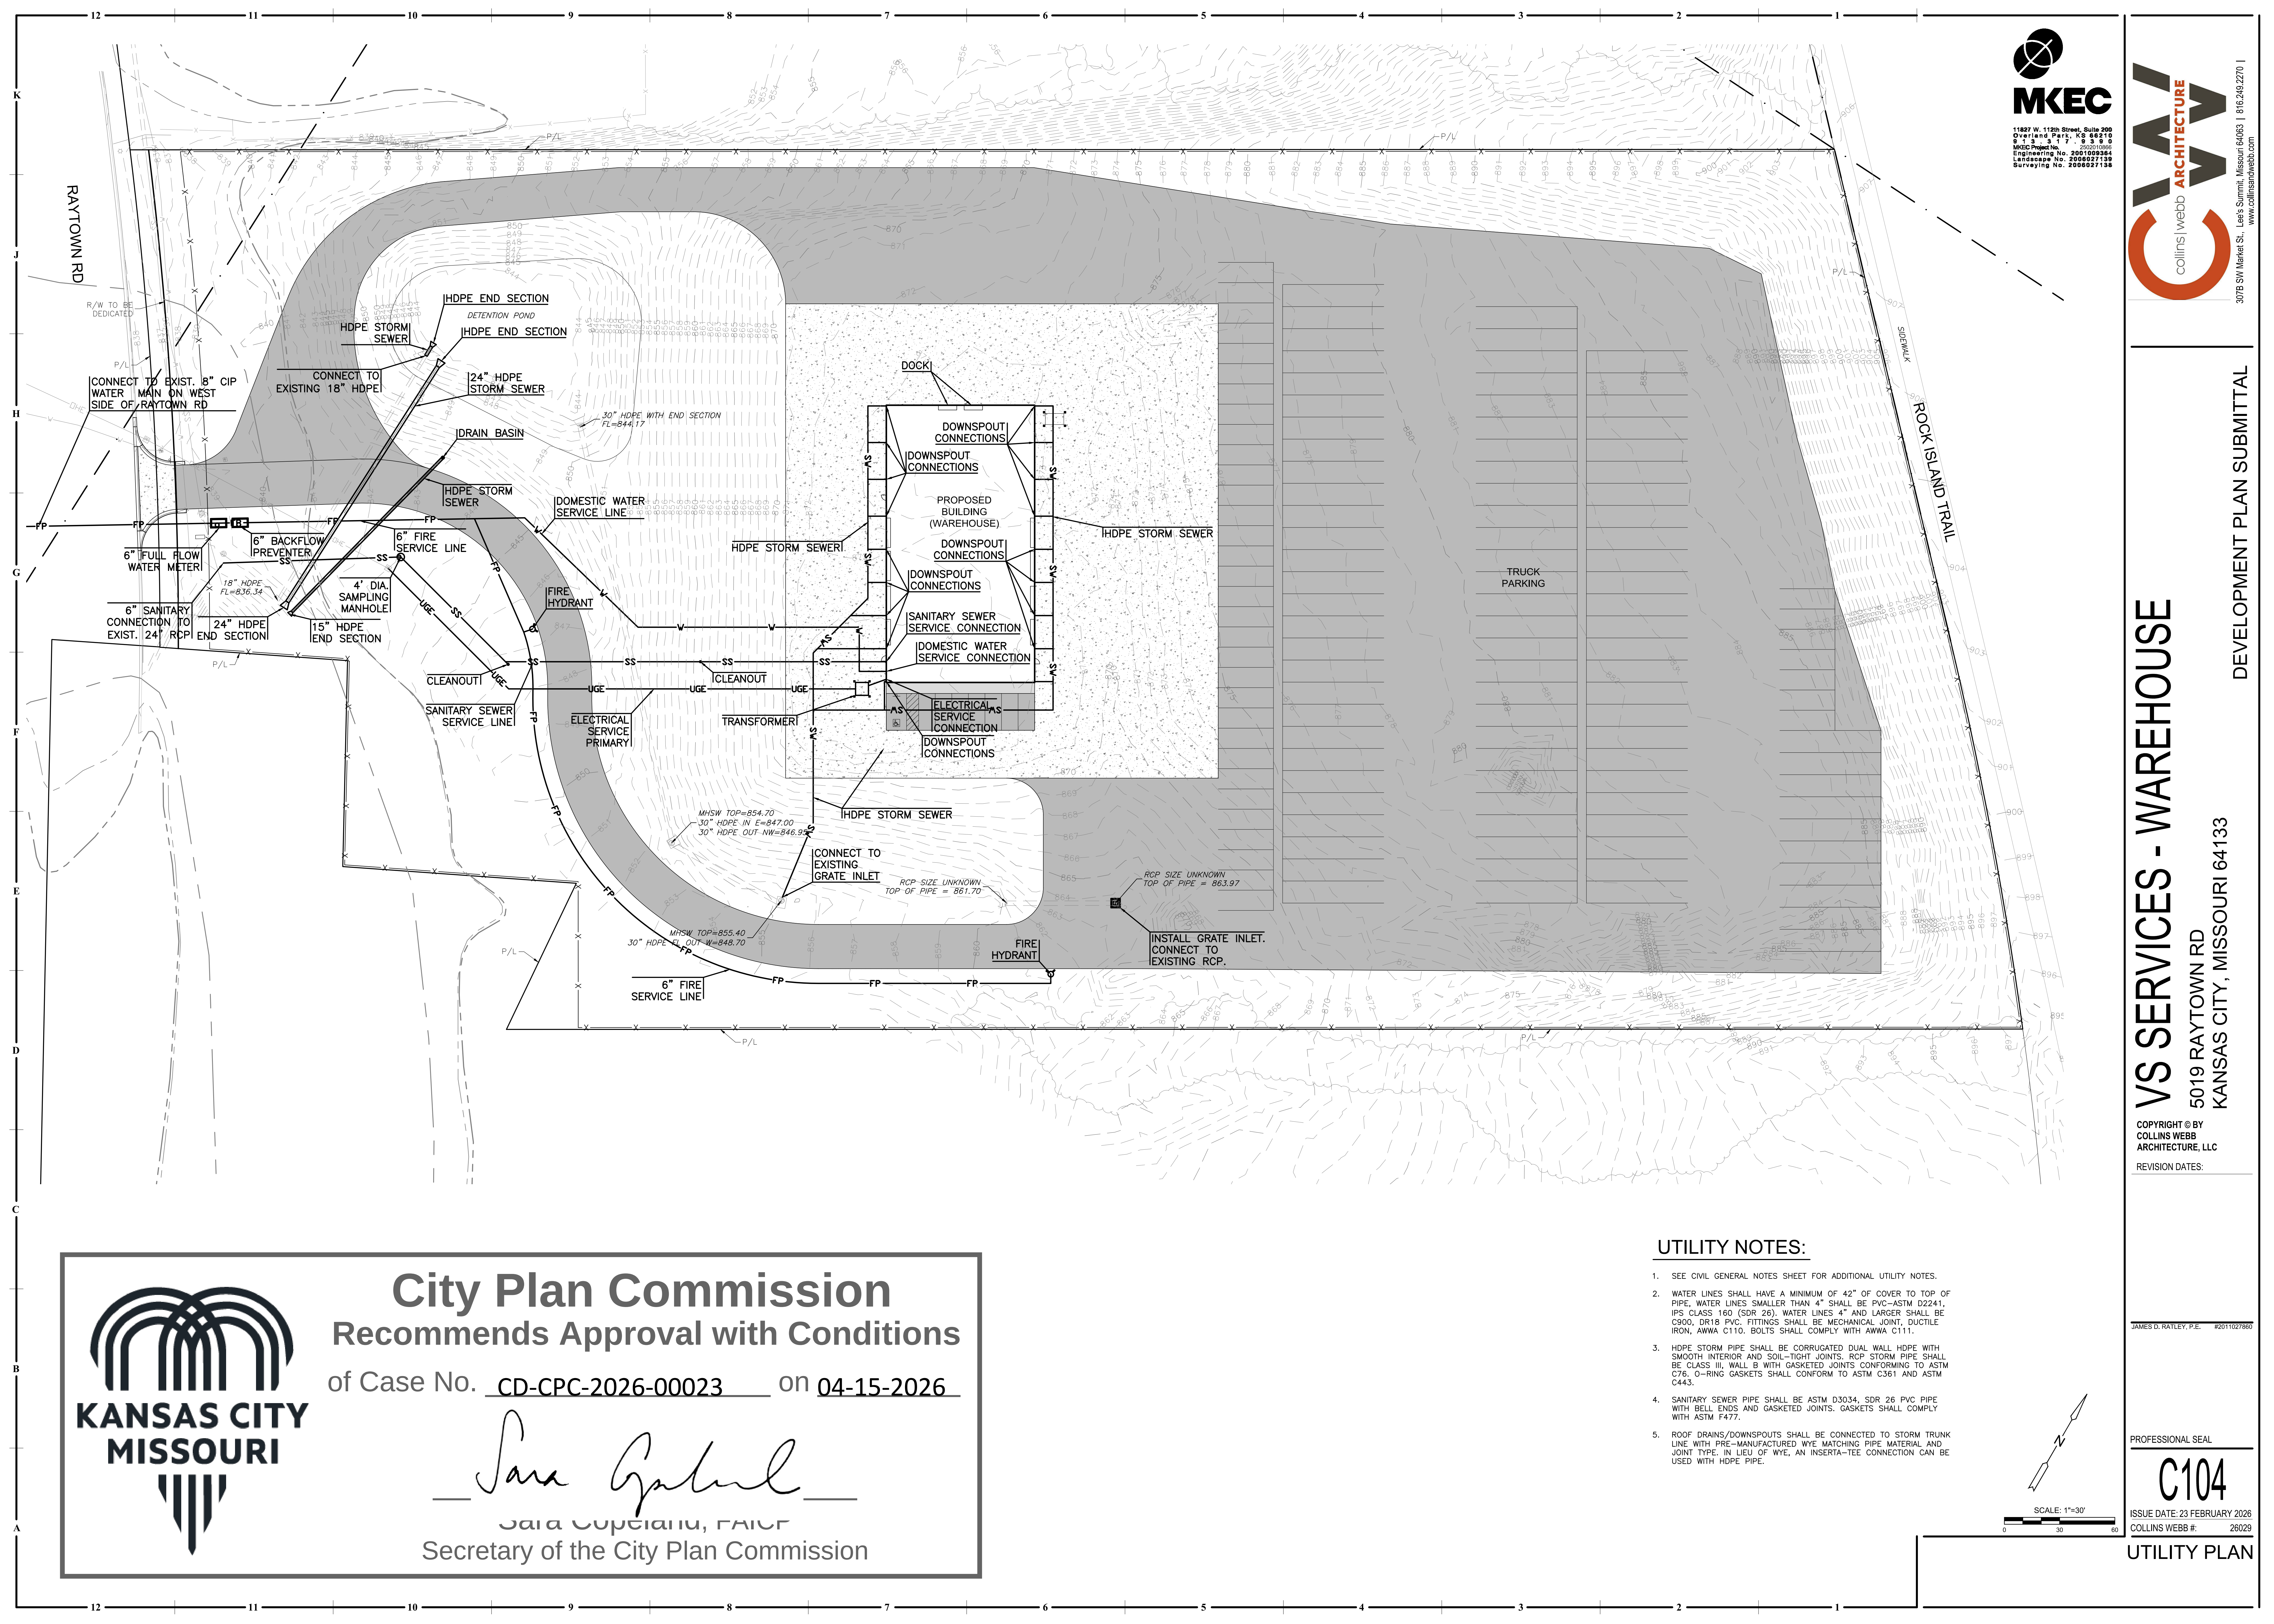

**MKEC**  
11227 W. 112th Street, Suite 200  
Overland Park, KS 66210  
913.241.1100  
MKEC is a member of the  
Engineering No. 2007009364  
Landmark No. 2008027138  
Surveying No. 2008027138

**collins webb ARCHITECTURE**  
3076 SV Market St., Lee's Summit, Missouri 64063 | 816.249.2270 | www.collinswebb.com

**VS SERVICES - WAREHOUSE**  
5019 RAYTOWN RD  
KANSAS CITY, MISSOURI 64133  
DEVELOPMENT PLAN SUBMITTAL  
COPYRIGHT © BY  
COLLINS WEBB  
ARCHITECTURE, LLC  
REVISION DATES:

JAMES D. RATLEY, P.E. #2011027880  
PROFESSIONAL SEAL  
**C104**  
ISSUE DATE: 23 FEBRUARY 2026  
COLLINS WEBB # 26029  
**UTILITY PLAN**




# City Plan Commission

## Recommends Approval with Conditions

of Case No. CD-CPC-2026-00023 on 04-15-2026

*Sara Copeland*  
Sara Copeland, FAICP  
Secretary of the City Plan Commission

- UTILITY NOTES:**
- SEE CIVIL GENERAL NOTES SHEET FOR ADDITIONAL UTILITY NOTES.
  - WATER LINES SHALL HAVE A MINIMUM OF 42" OF COVER TO TOP OF PIPE. WATER LINES SMALLER THAN 4" SHALL BE PVC-ASTM D2241, IPS CLASS 150 (SDR 26). WATER LINES 4" AND LARGER SHALL BE C900, DR18 PVC. FITTINGS SHALL BE MECHANICAL JOINT, DUCTILE IRON, AWWA C110. BOLTS SHALL COMPLY WITH AWWA C111.
  - HDPE STORM PIPE SHALL BE CORRUGATED DUAL WALL HDPE WITH SMOOTH INTERIOR AND SOIL-TIGHT JOINTS. RCP STORM PIPE SHALL BE CLASS III, WALL B WITH GASKETED JOINTS CONFORMING TO ASTM C78. O-RING GASKETS SHALL CONFORM TO ASTM C361 AND ASTM C443.
  - SANITARY SEWER PIPE SHALL BE ASTM D3034, SDR 26 PVC PIPE WITH BELL ENDS AND GASKETED JOINTS. GASKETS SHALL COMPLY WITH ASTM F477.
  - ROOF DRAINS/DOWNSPOUTS SHALL BE CONNECTED TO STORM TRUNK LINE WITH PRE-MANUFACTURED WYE MATCHING PIPE MATERIAL AND JOINT TYPE. IN LIEU OF WYE, AN INSERT-TEE CONNECTION CAN BE USED WITH HDPE PIPE.

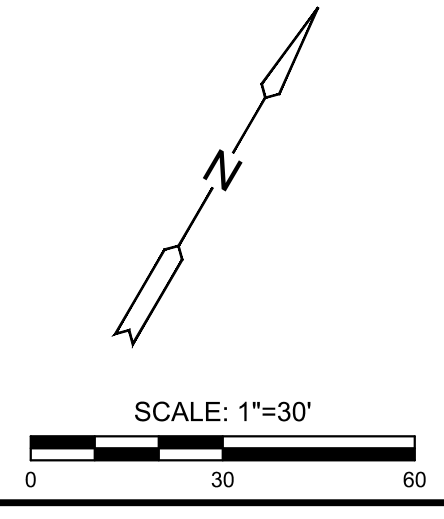



107B SW Market St., Lee's Summit, Missouri 64063 | 816.249.2270 | [www.collinsandcobb.com](http://www.collinsandcobb.com)

5019 RAYTOWN RD  
KANSAS CITY, MISSOURI 64133


**COPYRIGHT © BY  
COLLINS WEBB  
ARCHITECTURE, LLC**

REVISION DATES:





ISSUE DATE: 04-03-26  
COLLINS WEBB #: 26029

LANDSCAPE PLAN

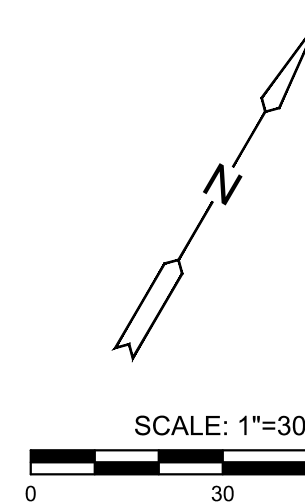of Case No. CD-CPC-2026-00023 on 04-15-2026

  Sara Copeland, FAICP  
Secretary of the City Plan Commission

| PLANT SCHEDULE                                                                        |      |           |                   |                                 |        |
|---------------------------------------------------------------------------------------|------|-----------|-------------------|---------------------------------|--------|
| SYMBOL                                                                                | CODE | QTY       | COMMON NAME       | BOTANICAL NAME                  | CONT   |
| TREES                                                                                 |      |           |                   |                                 |        |
|  | AMS  | 7         | AMERICAN SYCAMORE | PLATANUS OCCIDENTALIS           | FG B&B |
|  | SHU  | 7         | SHUMARD OAK       | QUERCUS SHUMARDII               | FG B&B |
| SHRUBS                                                                                |      |           |                   |                                 |        |
|  | RTD  | 24        | RED TWIG DOGWOOD  | CORNUS SERICEA                  | 3 GAL  |
|  | SGJ  | 24        | SEA GREEN JUNIPER | JUNIPERUS CHINENSIS 'SEA GREEN' | 3 GAL  |
| GROUND COVERS                                                                         |      |           |                   |                                 |        |
|  | P3P  | 11,123 SF | PRAIRIE 3 PLUS    | PRAIRIE SEED                    | SEED   |
|  | SEED | 71,643 SF | FESCUE EDGE       | CAREX FESTUCACEA                | SEED   |

GENERAL LANDSCAPE NOTES:

1.

THE LANDSCAPE CONTRACTOR SHOULD READ ALL LANDSCAPE PLANS, SPECIFICATIONS AND VISIT THE PROJECT SITE TO BECOME FAMILIAR WITH THE EXISTING CONDITIONS PRIOR TO BIDDING THIS PROJECT. IF A DISCREPANCY BETWEEN PLANT QUANTITIES SHOWN ON PLANS AND WITHIN THE PLANT SCHEDULE EXIST THE PLANS QUANTITIES SHALL BE USED. PLANT SCHEDULE QUANTITIES FOR INFORMATION ONLY.
2.

ANY AND ALL QUESTIONS CONCERNING THE LANDSCAPE PLANS AND SPECIFICATIONS SHALL BE DIRECTED TO THE OWNER AND / OR MKEC LANDSCAPE ARCHITECT AT 913-317-9390.
3.

THE LANDSCAPE CONTRACTOR IS TO VERIFY THE LOCATION OF ALL UNDERGROUND UTILITIES (INCLUDING THOSE INDICATED ON THE PLAN) PRIOR TO INSTALLATION OF PLANT MATERIAL.
4.

THE LANDSCAPE CONTRACTOR SHALL BE RESPONSIBLE FOR WATERING, MULCHING, AND OTHER REQUIREMENTS OF PLANT MATERIALS WHILE THEY ARE TEMPORARILY STORED ON OR OFF SITE.
5.

THE LANDSCAPE CONTRACTOR SHALL COORDINATE LAYOUT OF PLANTING BEDS, PLANT MASSING, STAKED LOCATION OF TREES AND INSTALLATION OF PLANT MATERIAL WITH OWNER PRIOR TO COMMENCEMENT OF WORK.
6.

ALL PLANT MATERIAL (EXCEPT SHADE TREES) IS DELINEATED AT MATURE SIZE OF PLANT MATERIAL. SHADE TREES ARE DELINEATED AT 85% OF ACTUAL MATURE SIZE.
7.

ALL PLANT MATERIALS MEET THE AMERICAN STANDARD FOR NURSERY STOCK (ANSI Z60.1-1996) PER THE AMERICAN ASSOCIATION OF NURSERYMEN.
8.

PER OWNER'S DIRECTION, THE LANDSCAPE ARCHITECT RESERVES THE RIGHT TO INSPECT ALL PLANT MATERIAL AT THE NURSERY, PRIOR TO DIGGING.
9.

AREAS DISTURBED AREAS SHALL BE "FESCUE TURF" ARE TO RECEIVE SOD AS FOLLOWS:  
SOD: FESCUE TURF.  
FERTILIZER: HAVE SOIL TESTED TO OBTAIN RECOMMENDED SOIL AMENDMENTS FOR THE GRASSES LISTED. REPORT RECOMMENDATIONS TO THE LANDSCAPE ARCHITECT FOR APPROVAL BEFORE ANY APPLICATION OF FERTILIZER IS MADE.
10.

CONDUCT PLANTING UNDER FAVORABLE WEATHER CONDITIONS DURING EITHER THE SPRING PLANTING SEASON, MARCH 1ST TO JUNE 1ST, OR THE FALL PLANTING SEASON, SEPTEMBER 30TH UNTIL FREEZING OF THE GROUND. DURING THE FALL PLANTING SEASON, CONIFEROUS MATERIAL PLANTING SHALL BE CONDUCTED AUGUST 15TH TO OCTOBER 1ST. DEVIATION FROM THE ABOVE PLANTING DATES WILL ONLY BE PERMITTED WITH APPROVAL IN WRITING BY THE LANDSCAPE ARCHITECT.
11.

THE PLANTING SOIL MIXTURE FOR ALL TREE PLANTINGS SHALL INCLUDE SOIL EXCAVATED FROM THE HOLE. RATIO: 50% VIRGIN SOIL + 50% AMENDED TOP SOIL.
12.

ROOT STIMULATOR SHALL BE APPLIED TO ALL PLANT MATERIALS WITH THE EXCEPTION OF LAWN AREAS. APPLY AS PER THE MANUFACTURERS RECOMMENDATIONS.
13.

THE LANDSCAPE CONTRACTOR SHALL RESTORE FINISH GRADES IN ALL PLANTING AREAS (PER GRADING PLANS) WHICH MAY HAVE BEEN DISTURBED DURING PLANTING OPERATIONS.
14.

ALL TREE SAUCERS AND PLANTING BEDS ARE TO BE MULCHED WITH A MINIMUM OF 4" DOUBLE-GROUND OAK MULCH (COLOR DIED); COLOR TO BE "JAVA BROWN". WHERE PLANTING BEDS ARE ADJACENT TO WALKS AND CURBS THE SOIL LEVEL SHALL BE 4" LOWER TO ALLOW FOR MULCH LAYER. WHERE SOD IS INDICATED, ITS THICKNESS SHALL ALSO BE ACCOUNTED FOR SO THAT THE SOIL SURFACE IN THE SOD IS 1/2" BELOW THE HARDSCAPE SURFACE.
15.

ALL PLANTING BEDS SHALL BE TREATED WITH A PRE-EMERGENT HERBICIDE SUCH AS TREFLAN OR EQUAL. APPLY AS PER MANUFACTURER'S RECOMMENDATION. THE PRE-EMERGENT SHALL NOT BE APPLIED UNTIL AFTER ALL PLANTING WITHIN THESE AREAS IS COMPLETE, BUT BEFORE THESE AREAS ARE MULCHED. DO NOT DISTURB AREAS AFTER APPLICATION. WATER AS DIRECTED.
16.

MULCH, STAKES, GUY WIRE, PRE-EMERGENT HERBICIDES, ETC. SHALL BE SUBSIDIARY TO INDIVIDUAL PLANTS.
17.

LANDSCAPE EDGING: ALL PLANTING BEDS ABUTTING LAWN AREAS SHALL BE EDGED WITH BLACK STEEL EDGING.
18.

ALL SLOPES THAT EXCEED A 3:1 GRADE SHALL BE PROTECTED WITH AN EROSION CONTROL BLANKET - NORTH AMERICAN GREEN S150. INSTALL AS PER THE MANUFACTURER'S RECOMMENDATIONS.
19.

LABEL EACH TREE AND SHRUB WITH A SECURELY ATTACHED, WATERPROOF TAG BEARING LEGIBLE DESIGNATION OF BOTH BOTANICAL AND COMMON NAME. LABEL EACH ORNAMENTAL GRASS, GROUNDCOVER, PERENNIAL AND ANNUAL WITH THE LABEL PROVIDED BY THE ORIGINAL GROWER OF THE PLANT. LABELS SHALL NOT BE REMOVED UNTIL AFTER PROVISIONAL ACCEPTANCE BY THE LANDSCAPE ARCHITECT.
20.

STAKES AND GUYING SHALL BE REMOVED AT THE END OF ONE FULL GROWING SEASON.
21.

ALL PLANTING BEDS SHALL BE OVER EXCAVATED TO A DEPTH OF 2'. ALL AREAS DENOTED WITH SOD (LAWN AREAS) SHALL HAVE A 6" MINIMUM TOPSOIL LAYER. TOPSOIL SHALL BE LAID IN 3" LIFTS. IN AREAS WHERE CONSTRUCTION GRADING HAS NOT OCCURED AND THE VIRGIN GRADE YET EXIST, THE TOPSOIL LAYER MAY NOT BE REQUIRED BASED ON THE DECISION OF THE LANDSCAPE ARCHITECT.
22.

TOPSOIL SHALL BE FERTILE NATURAL TOPSOIL, TYPICAL OF THE LOCALITY, FOLLOWING MAJOR GRADING OPERATIONS THE FINAL 8" LIFT SHALL BE HIGH QUALITY TOPSOIL. SOIL SHALL BE OBTAINED FROM WELL DRAINED AREAS, STOCKPILED TOPSOIL MAY BE USED. IT SHALL BE WITHOUT ADMIXTURE OF SUBSOL OR SLAG AND SHALL BE FREE OF STONES, LUMPS, STICKS, PLANTS OR THEIR ROOTS, TOXIC SUBSTANCES OR OTHER EXTRANEOUS MATTER THAT MAY BE HARMFUL TO PLANT GROWTH OR WOULD INTERFERE WITH FUTURE MAINTENANCE. TOPSOIL PH RANGE SHALL BE 5.5 TO 7.0.
23.

THERE SHALL BE NO ADDITIONS, DELETIONS OR SUBSTITUTION OF PLANT MATERIAL SPECIES WITHOUT THE WRITTEN APPROVAL BY THE OWNER AND / OR MKEC LANDSCAPE ARCHITECT. ANY SUBSTITUTION WHICH HAS NOT BEEN APPROVED SHALL BE REMOVED AND IMMEDIATELY REPLACED WITH THE CORRECT PLANT AT LANDSCAPE CONTRACTOR'S EXPENSE.
24.

IN THE CONDITION WHERE THE PLANT MATERIAL HAS BEEN SUPPLIED BY THE OWNER THROUGH A PLANT PROCUREMENT PROGRAM WITH A MYKE PRO 2 YEAR WARRANTY, THE LANDSCAPE CONTRACTOR'S WARRANTY OF PLANT MATERIAL SHALL BEGIN FROM THE TIME OF HANDLING PLANT MATERIAL AT TIME OF DELIVERY THROUGH INSTALLATION AND END AFTER THE SUBSTANTIAL COMPLETION AND FINAL PUNCH-LIST APPROVAL BY LANDSCAPE ARCHITECT.
25.

THE LANDSCAPE CONTRACTOR WILL BE RESPONSIBLE FOR THE COLLECTION, REMOVAL, AND PROPER DISPOSAL OF ANY AND ALL DEBRIS GENERATED DURING THE INSTALLATION OF THE LANDSCAPE CONSTRUCTION.
26.


THE CONTRACTOR SHALL FURNISH TOPSOIL; TOPSOIL MUST BE APPROVED BY THE LANDSCAPE ARCHITECT. REFER TO SPECIFICATIONS FOR TOPSOIL REQUIREMENTS.
27.

THE CONTRACTOR SHALL SUPPLY ALL PLANTING SOIL MIX.
28.

ALL LANDSCAPE AREAS SHALL BE IRRIGATED BY A TEMPORARY IRRIGATION SYSTEM.
29.


THE PLANTING SOIL MIX SHALL BE APPROVED BY THE LANDSCAPE CONTRACTOR PRIOR TO ANY BACKFILLING.
30.

THE TYPICAL PLANTING SOIL MIX FOR ALL PLANTING BEDS (SHRUBS, ORNAMENTAL GRASS AND PERENNIAL BED AREAS) SHALL CONSIST OF THE FOLLOWING MAKE-UP UNLESS OTHERWISE INDICATED IN THESE PLANS:  
- 80% TOPSOIL AS SPECIFIED  
- 20% PREPARED ADDITIVES (BY VOLUME AS FOLLOWS):
  - 2 PARTS HUMAS AND/OR PEAT
  - 1 PART STERILIZED COW MANURE
  - 1 PART SHREDDED PINE BARK (BARK PIECES BETWEEN 1/2"AND 1-1/2" IN LENGTH/DIAMETER).- COMMERCIAL FERTILIZER AS RECOMMENDED BY SOIL REPORT.  
- LIME AS RECOMMENDED BY SOIL REPORT.

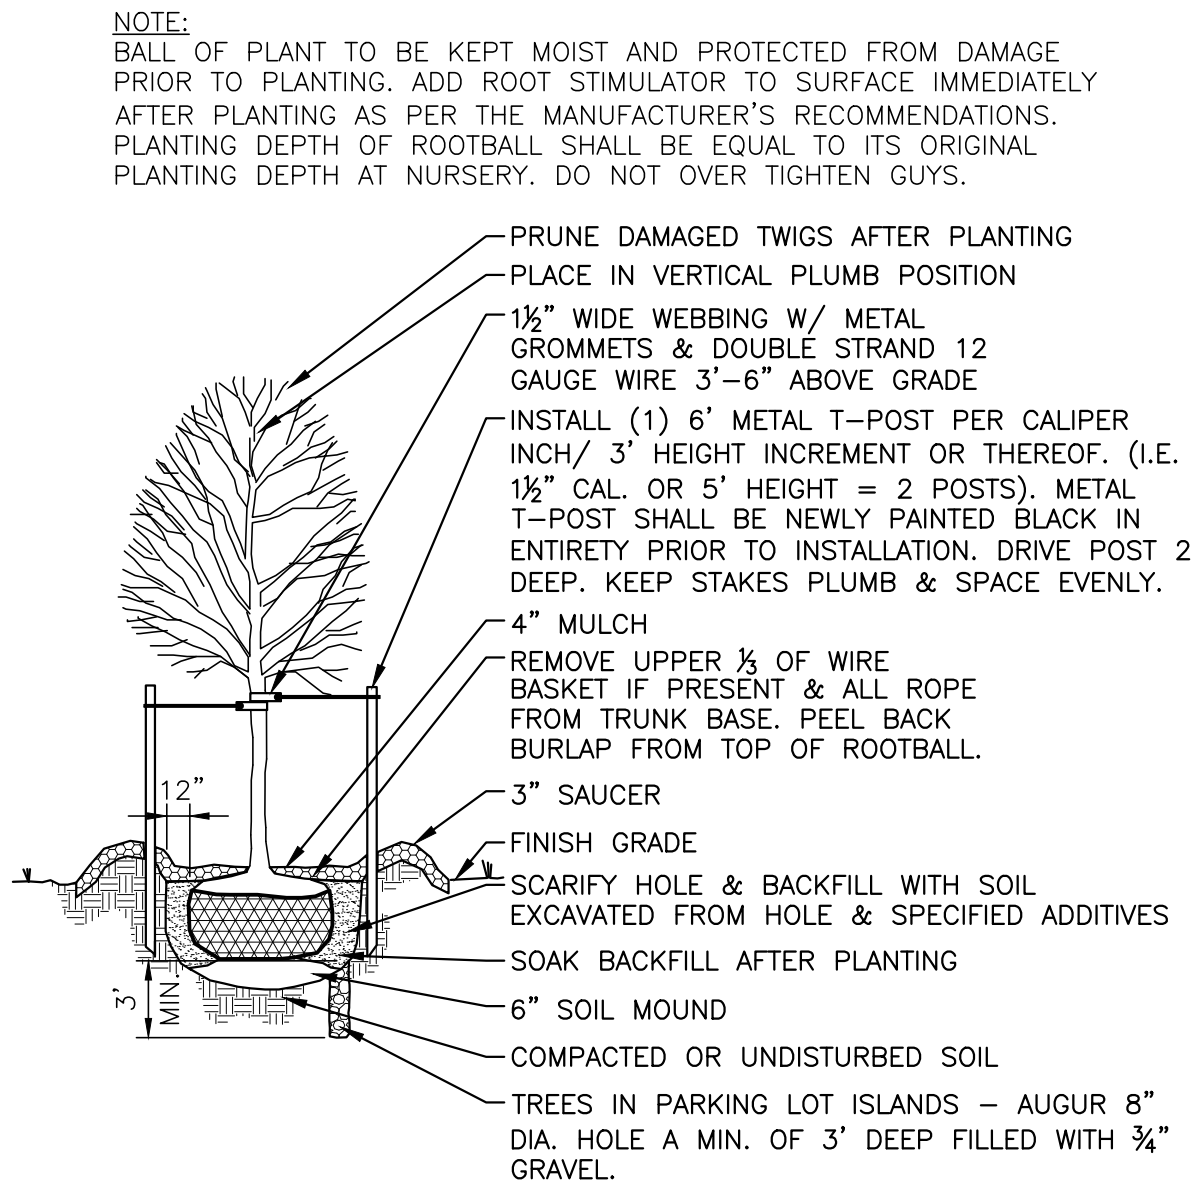


DECIDUOUS TREE PLANTING

SCALE: NTS

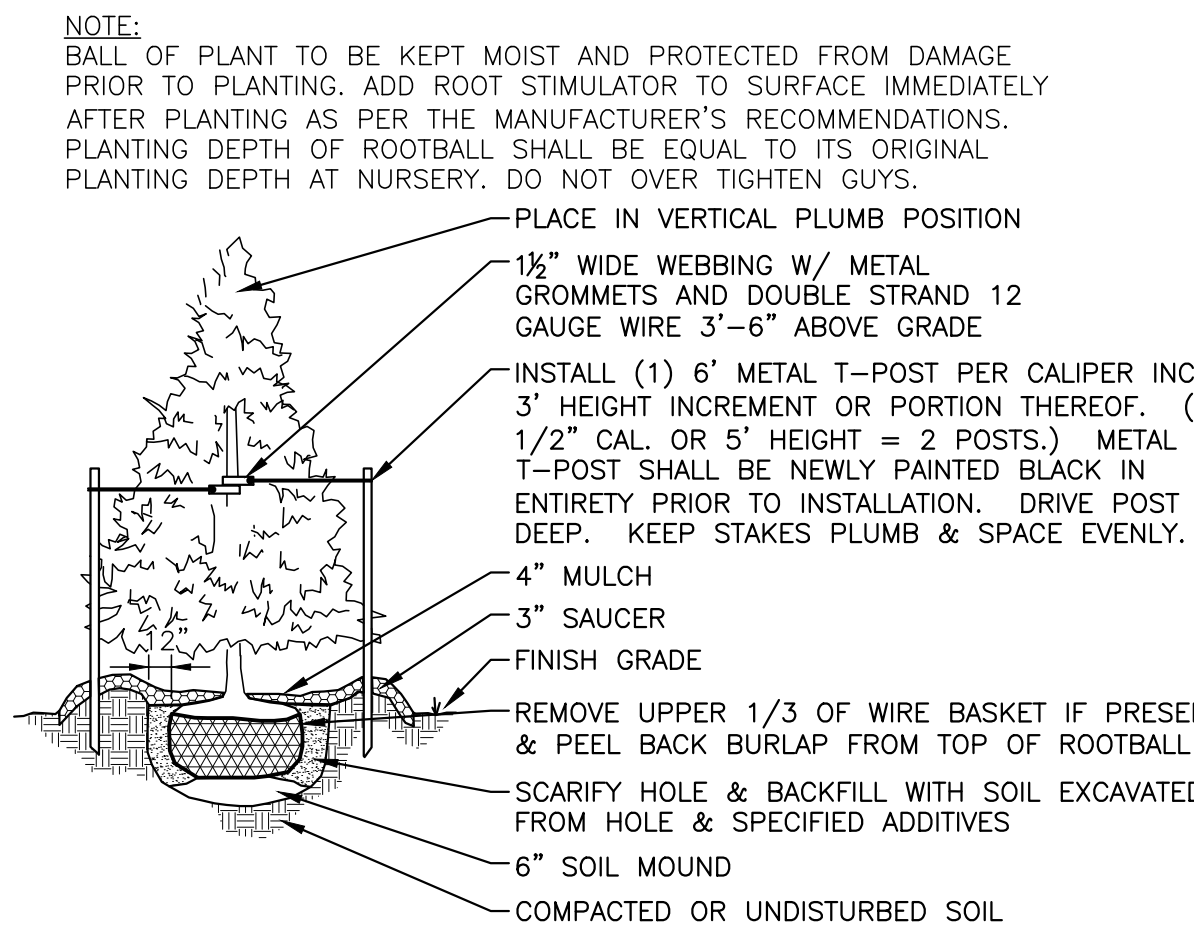


EVERGREEN TREE PLANTING

SCALE: NTS

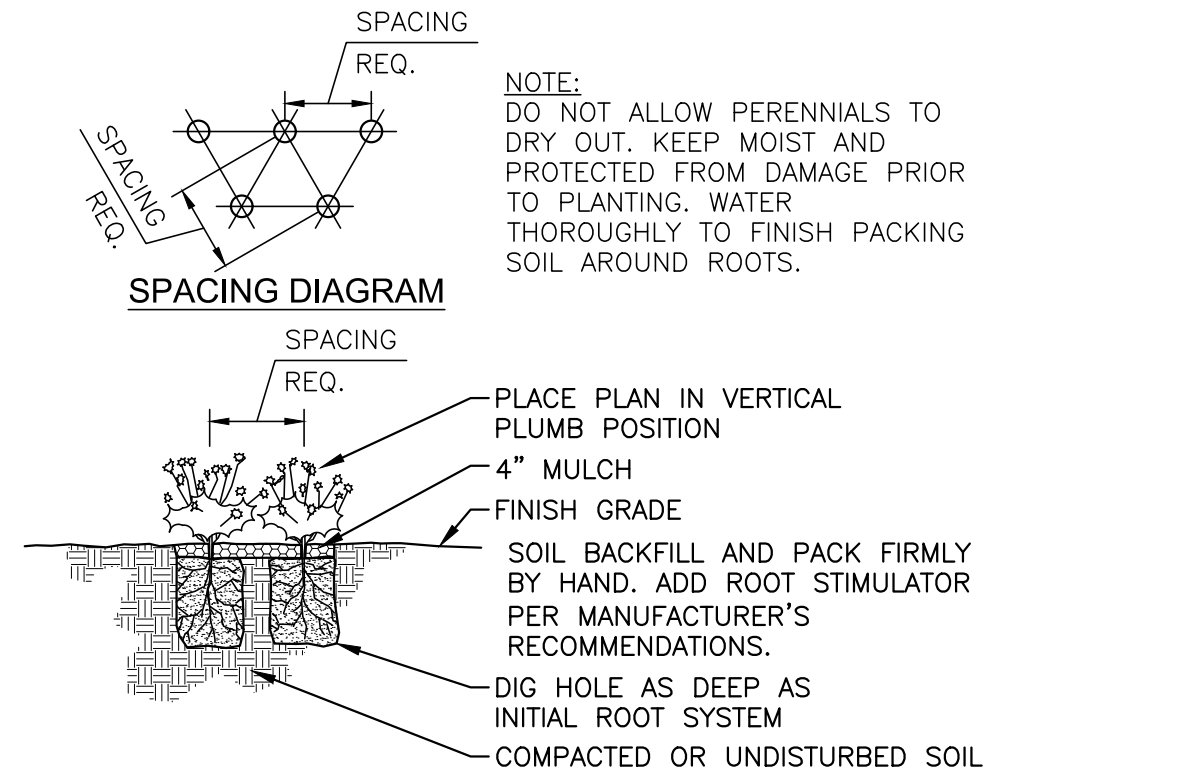


PERENNIAL PLANTING

SCALE: NTS

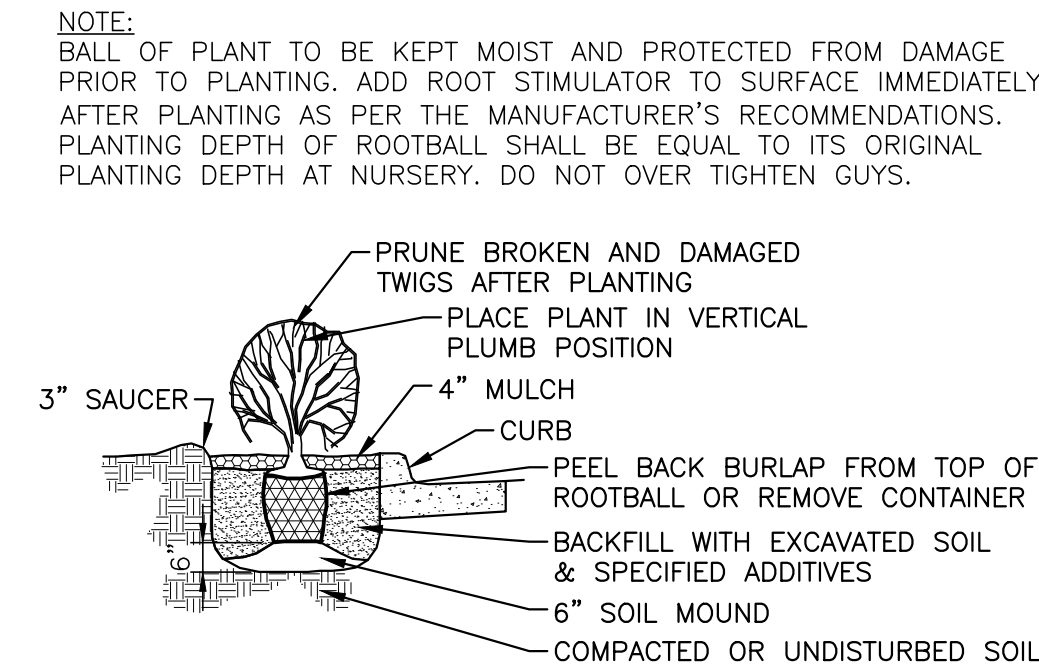


SHRUB PLANTING  
ADJACENT TO CURB

SCALE: NTS

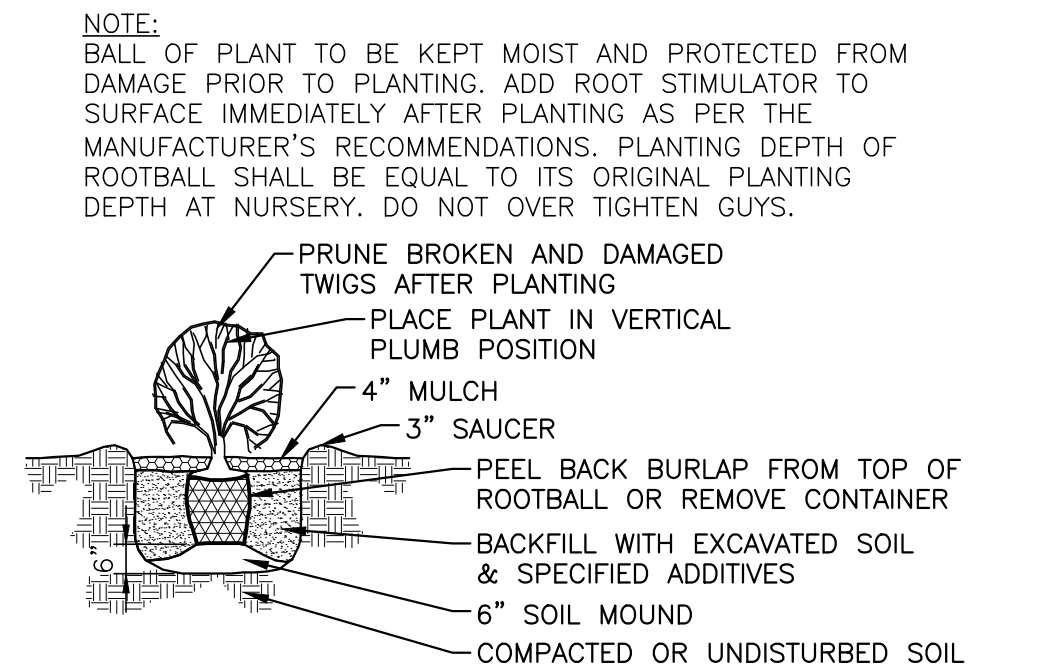

SHRUB PLANTING

SCALE: NTS

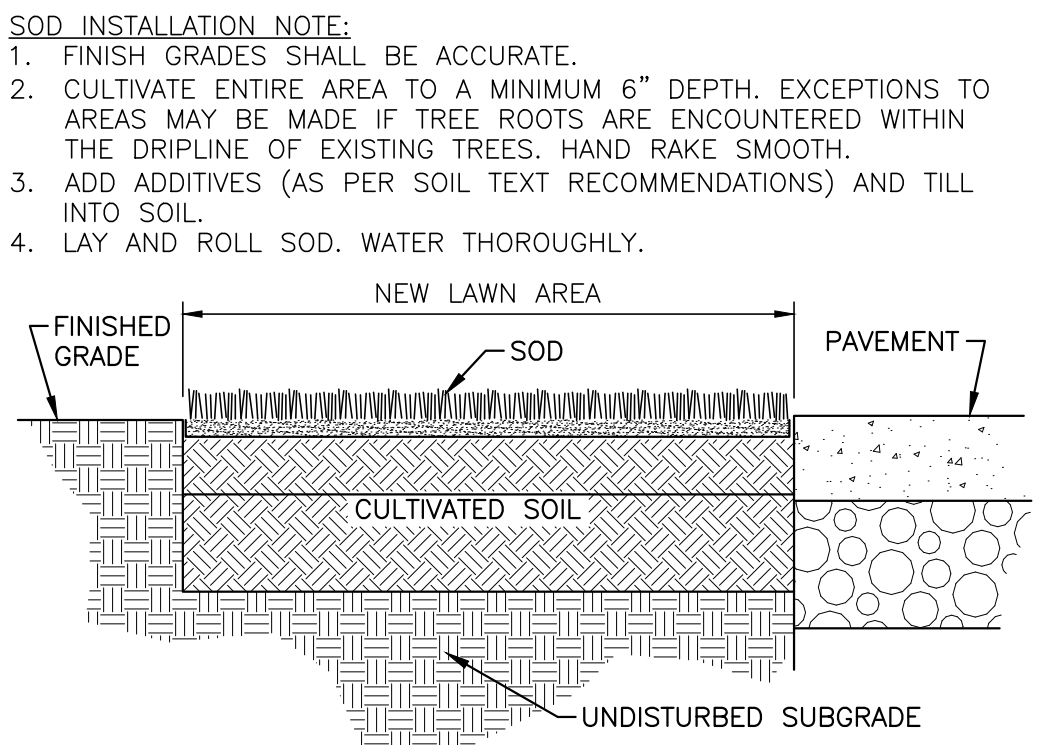

SOD INSTALLATION

SCALE: NTS



City Plan Commission  
Recommends Approval with Conditions

of Case No. CD-CPC-2026-00023 on 04-15-2026

*Sara Cooperian*

Sara Cooperian, FAICP  
Secretary of the City Plan Commission



11827 W. 112th Street, Suite 200  
Overland Park, KS 66210  
913-317-9390  
MKEC Project No. 2007-009364  
Landscape No. 20080227138  
Surveying No. 20080227138



3076 SW Market St. Lee's Summit, Missouri 64063 | 816.249.2270 |  
www.collinswebb.com

VS SERVICES - WAREHOUSE

5019 RAYTOWN RD  
KANSAS CITY, MISSOURI 64133

COPYRIGHT © BY  
COLLINS WEBB  
ARCHITECTURE, LLC

REVISION DATES:

BRIAN J HOCHSTEIN


PROFESSIONAL SEAL

L101

ISSUE DATE: 23 FEBRUARY 2026  
COLLINS WEBB #: 28029

LANDSCAPE NOTES

2/19/2026 3:28:31 PM

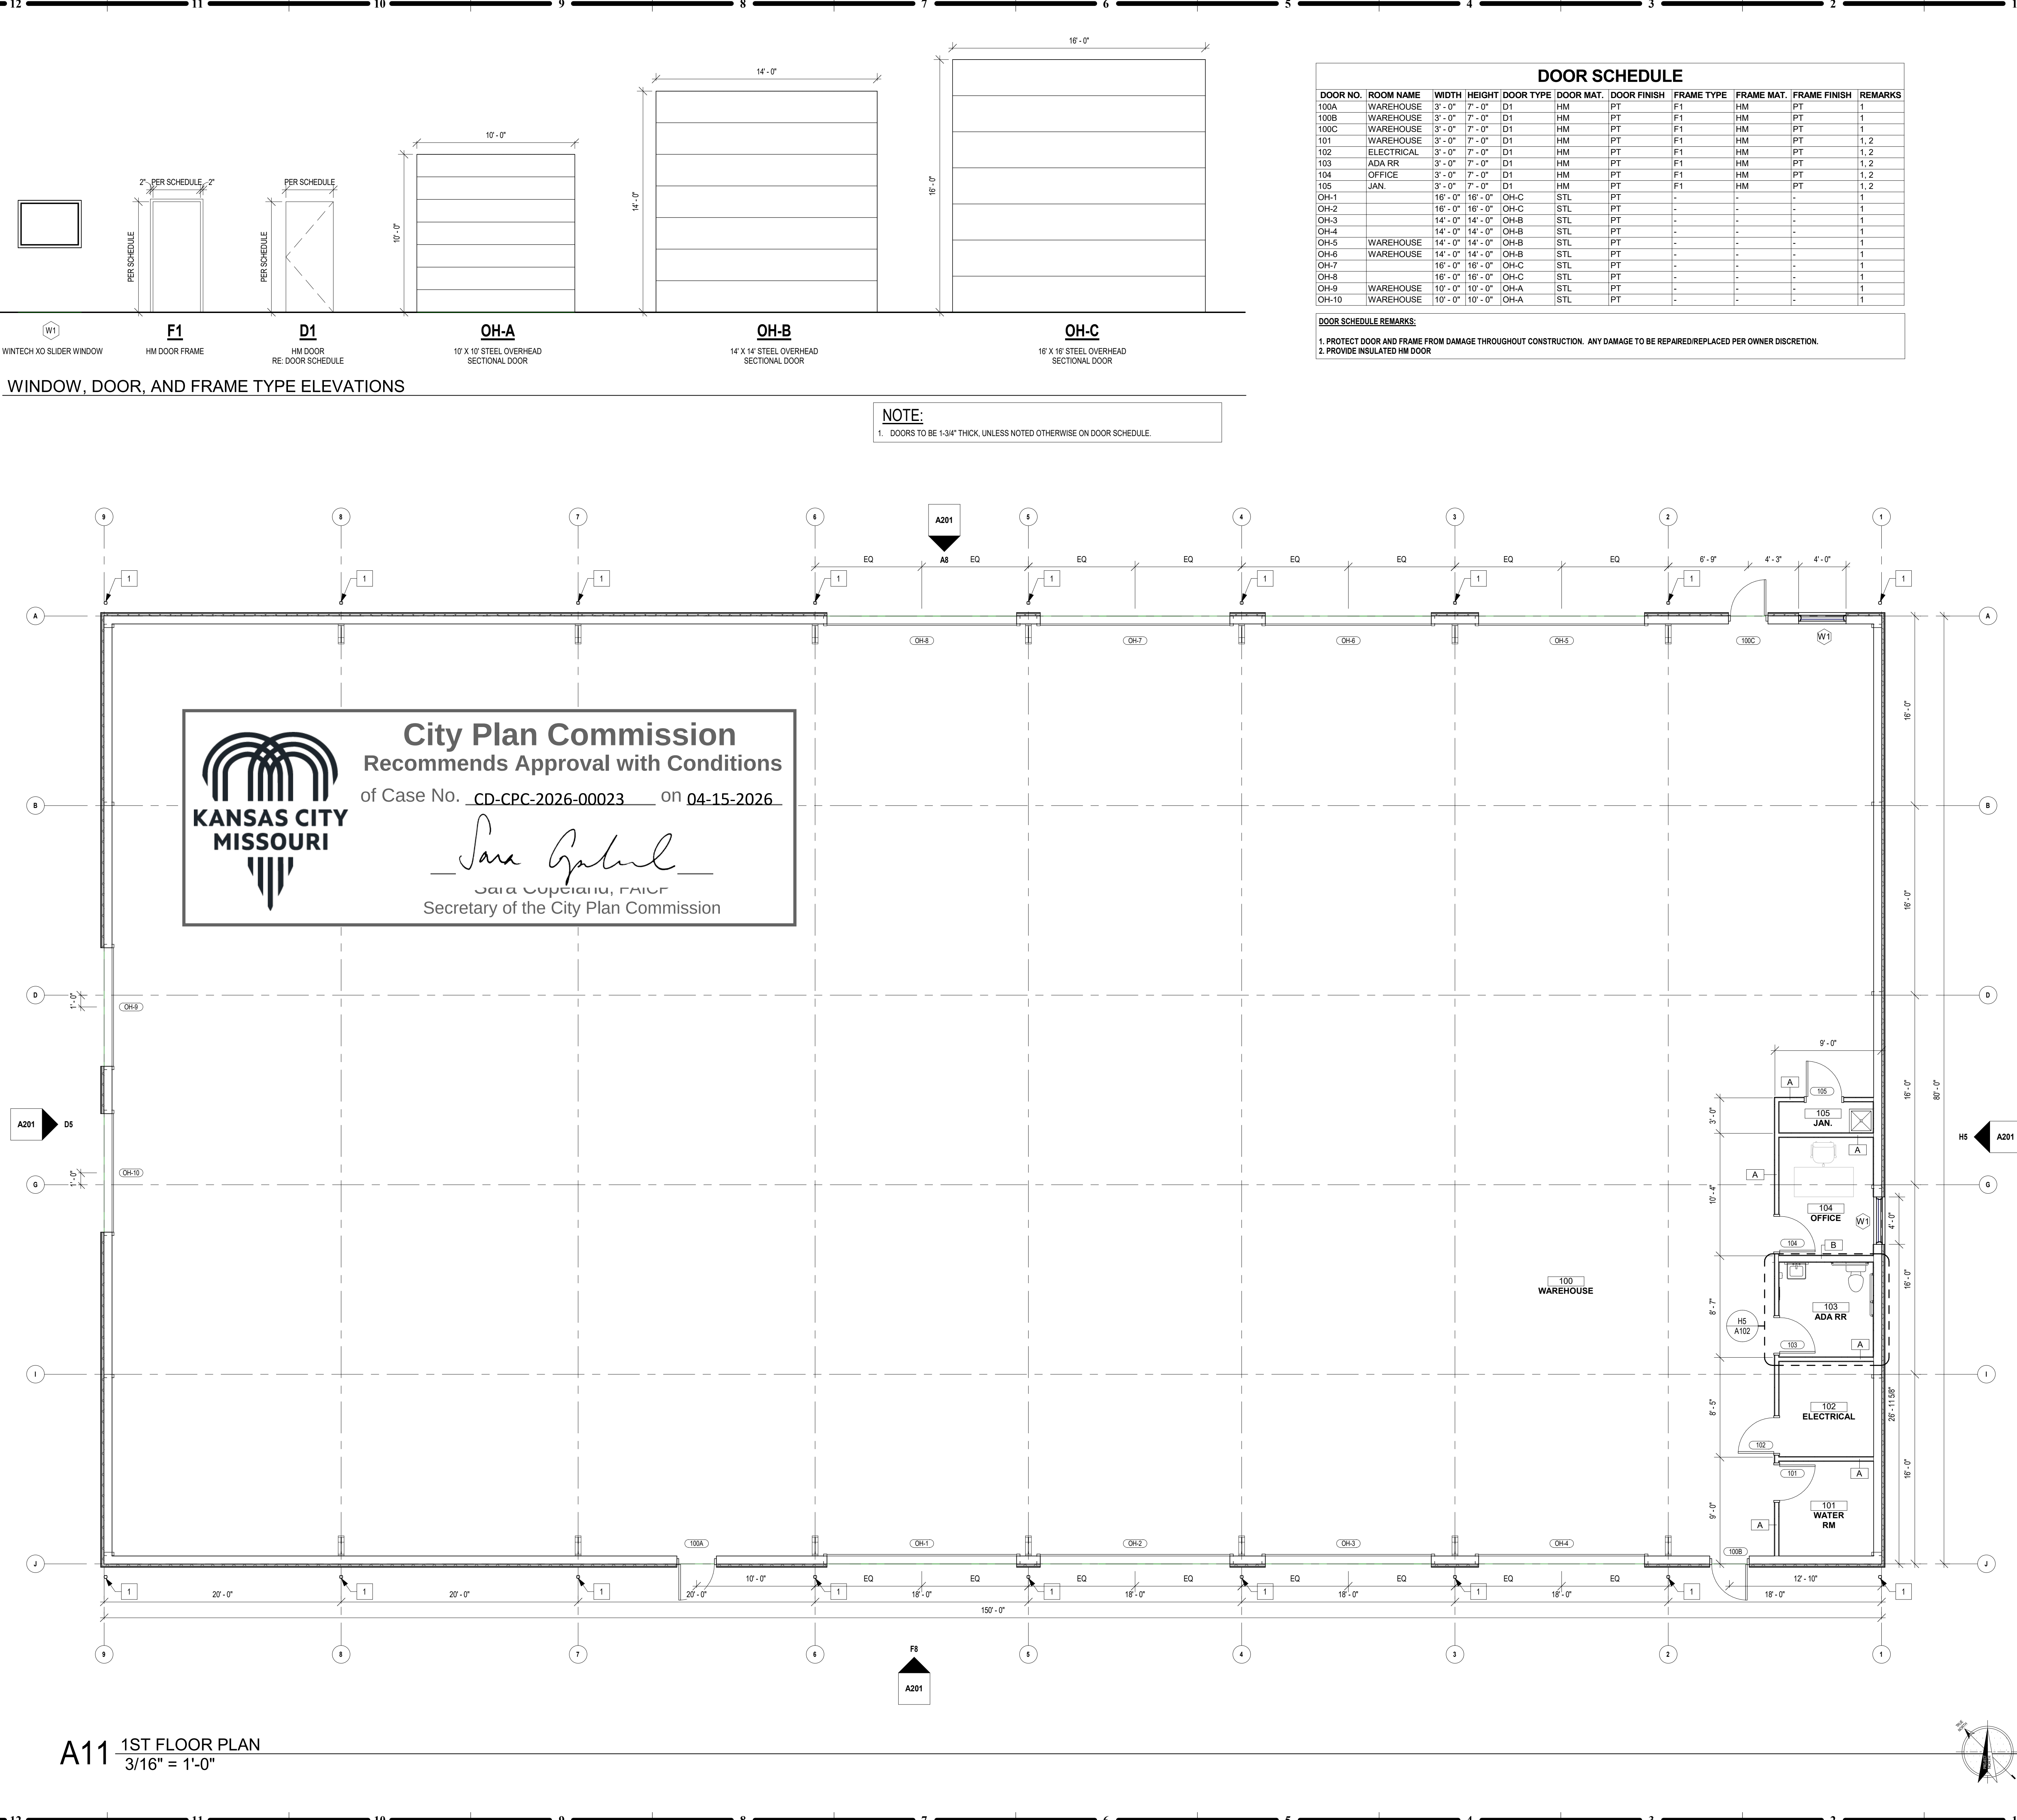

**GENERAL NOTES:**

**DOOR SCHEDULE**

- HM REFERS TO HOLLOW METAL.
- AL REFERS TO ALUMINUM
- WD REFERS TO WOOD
- SOWD REFERS TO SOLID CORE WOOD
- ALL EXTERIOR ALUMINUM DOORS & FRAMES ARE TO BE FINISHED TO MATCH ADJACENT ALUMINUM WINDOW FRAME, UNO.
- FOR FINISH COLOR DESIGNATION FOR INTERIOR DOOR AND FRAMES, REFER TO FINISH LEGEND.
- REFER TO SPECIFICATION FOR DOOR HARDWARE SET DESIGNATIONS.
- 2 HOUR FIRE BARRIED DOORS = 90 MINUTE RATING
- 1 HOUR FIRE BARRIED DOORS = 20 MINUTE RATING
- 1 HOUR SMOKE BARRIER = 20 MINUTE RATING
- PROTECT ALL DOORS & FRAMES FROM DAMAGE THROUGHOUT CONSTRUCTION PHASES.
- ALL EGRESS DOORS TO BE PROVIDED WITH PANIC HARDWARE

**GENERAL NOTES:**

**FLOOR PLANS**

- SEE GENERAL ARCHITECTURAL SHEETS FOR ADDITIONAL NOTES AND DETAILS THAT ARE APPLICABLE.
- ARCHITECTURAL ELEVATION 100'-0"
- DIMENSIONS SHOWN ON THE FLOOR PLAN ARE TO THE FACE OF STUD (FOS), FACE OF MASONRY (FOM), FACE OF CONCRETE WALLS (FCW), AND COLUMN GRID LINES, UNLESS NOTED OR SHOWN OTHERWISE.
- NOTE: WALL THICKNESSES ARE ACTUAL DIMENSIONS AND PER WALL TYPES. SEE GENERAL SHEETS.
- DOOR OPENINGS NOT LOCATED BY DIMENSION SHALL BE CENTERED IN WALL SHOWN OR LOCATED 4 INCHES FROM FINISH WALL TO HINGE SIDE OF THE DOOR, ALWAYS ALLOWING A MINIMUM OF 18" FROM THE PULL SIDE (STRIKE SIDE) OF THE DOOR TO THE INTERSECTING WALL, OR OTHER PROTRUDING OBJECTS.
- ALL ALCOVES WITHOUT A SPACE IDENTIFICATION NUMBER SHALL HAVE THE SAME FINISHES AS THE ADJOINING SPACES.
- ALL WALLS TO BE PROVIDED WITH A LEVEL 4 FINISH UNLESS NOTED OTHERWISE.
- RE: FINISH LEGEND, FINISH SCHEDULE AND SPECIFICATIONS FOR DOOR AND DOOR FRAME FINISHES.
- STAIR ENCLOSURES, SHUTT WALLS, EXIT PASSAGEWAYS AND EXTERIOR WALLS TO BE COORDINATED FOR PHASE OF WORK PER MATRIX AND PROJECT SCOPING.
- MAINTAIN AND PROTECT EXISTING EXPANSION JOINTS DURING CONSTRUCTION. PATCH/REPAIR/REPLACE TO MATCH EXISTING RATINGS AS REQUIRED ON THE SHELL PORTION OF PROJECT.
- ALL WOOD PRODUCTS TO BE FIRE-RETARDANT, INCLUDING BLOCKING AND PLYWOOD.

**KEYED NOTES:**

**FLOOR PLAN**

1 LOCATION FOR PRE-FINISHED DOWNSPOUT. (FROM PEMB MFR)

**VS SERVICES - WAREHOUSE**

5019 RAYTOWN RD  
KANSAS CITY, MISSOURI 64133

COPYRIGHT © BY  
COLLINS | WEBB  
ARCHITECTURE, LLC

REVISION DATES:

NOT FOR  
CONSTRUCTION

PROFESSIONAL SEAL

**A101**

ISSUE DATE: 23 FEBRUARY 2026  
COLLINS WEBB #: 26029

FLOOR PLANS - 1ST FLOOR

DEVELOPMENT PLAN SUBMITTAL

collins | webb  
ARCHITECTURE

307A SW Market St., Lees Summit, MO 64083 | 816.249.2270 | www.collinsandwebb.com


| ACCESSORY SCHEDULE |                                  |                                                |            |                      |         |
|--------------------|----------------------------------|------------------------------------------------|------------|----------------------|---------|
| TYPE MARK          | MANUFACTURER                     | DESCRIPTION                                    | MODEL      | FINISH               | REMARKS |
| 1                  | BOBRICK WASHROOM EQUIPMENT, INC. | Bobrick B-35903 Recessed Paper Towel Dispenser | B-35903    | SATIN                | 4       |
| 2                  | BOBRICK WASHROOM EQUIPMENT, INC. | Classic Series Surface Mounted Soap Dispenser  | B-40       | BLACK & GREY PLASTIC | 3       |
| 3                  | BOBRICK WASHROOM EQUIPMENT, INC. | GRAB BAR, 1-1/2" DIA., SS, 36"                 | B-6806-36  | SATIN, PEENED        | 3       |
| 4                  | BOBRICK WASHROOM EQUIPMENT, INC. | GRAB BAR, 1-1/2" DIA., SS, 42"                 | B-6806-42  | SATIN, PEENED        | 3       |
| 5                  | BOBRICK WASHROOM EQUIPMENT, INC. | GRAB BAR, 1-1/2" DIA., SS, 18"                 | B-6806-18  | SATIN, PEENED        | 3       |
| 6                  | BOBRICK WASHROOM EQUIPMENT, INC. | MIRROR - WELDED-FRAME 24" X 48"                | B-290 2448 | SATIN                | 3, 5    |

GENERAL NOTES:


A. ALL TOILET ACCESSORY LOCATIONS BASED ON FLOOR PLAN LAYOUT.  
B. REFER TO INTERIOR ELEVATIONS FOR ANY ACCESSORIES THAT MAY NOT SHOW UP ON THE PLANS.  
C. REFER TO G002 AND MANUFACTURER'S SPECIFICATIONS FOR MOUNTING HEIGHTS.  
D. COORDINATE ALL MOUNTING HEIGHTS W/ PLUMBING FIXTURES TO ALLOW PROPER OPERATION & INFORM ARCHITECT IN WRITING OF ANY CONFLICTS.  
E. G.C. TO VERIFY DIRECTLY W/ OWNER TO DETERMINE MOUNTING HEIGHTS, U.N.O.

REMARKS:


1. OWNER FURNISHED, OWNER INSTALLED.  
2. FF&E ITEM - OWNER FURNISHED, CONTRACTOR INSTALLED. REFER TO PLANS AND ELEVATIONS FOR FURTHER CLARIFICATION.  
3. SURFACE MOUNTED.  
4. RECESSED.  
5. MIRRORS TO BE CENTERED AT SINKS, TYP.

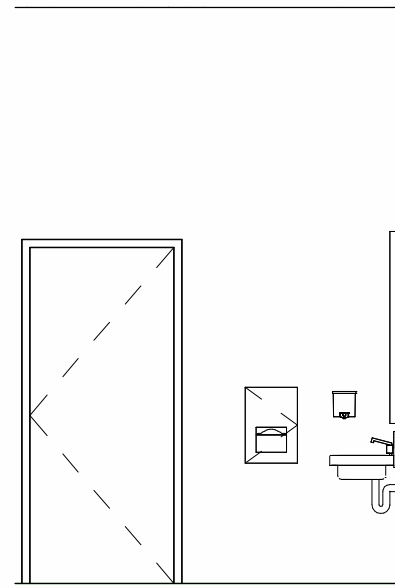


H7 INT. ELEV. - RR  
1/4" = 1'-0"

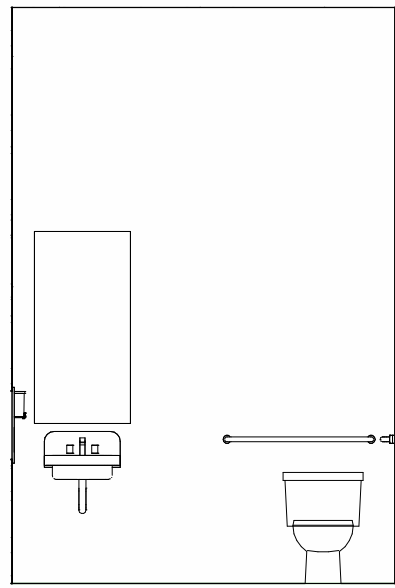

H6 INT. ELEV. - RR  
1/4" = 1'-0"

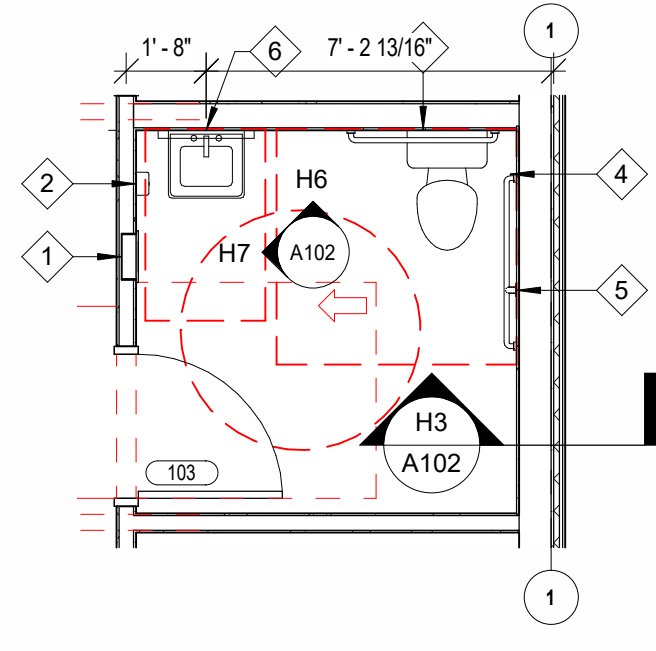

H5 ENLARGED PLAN - RESTROOM  
1/4" = 1'-0"

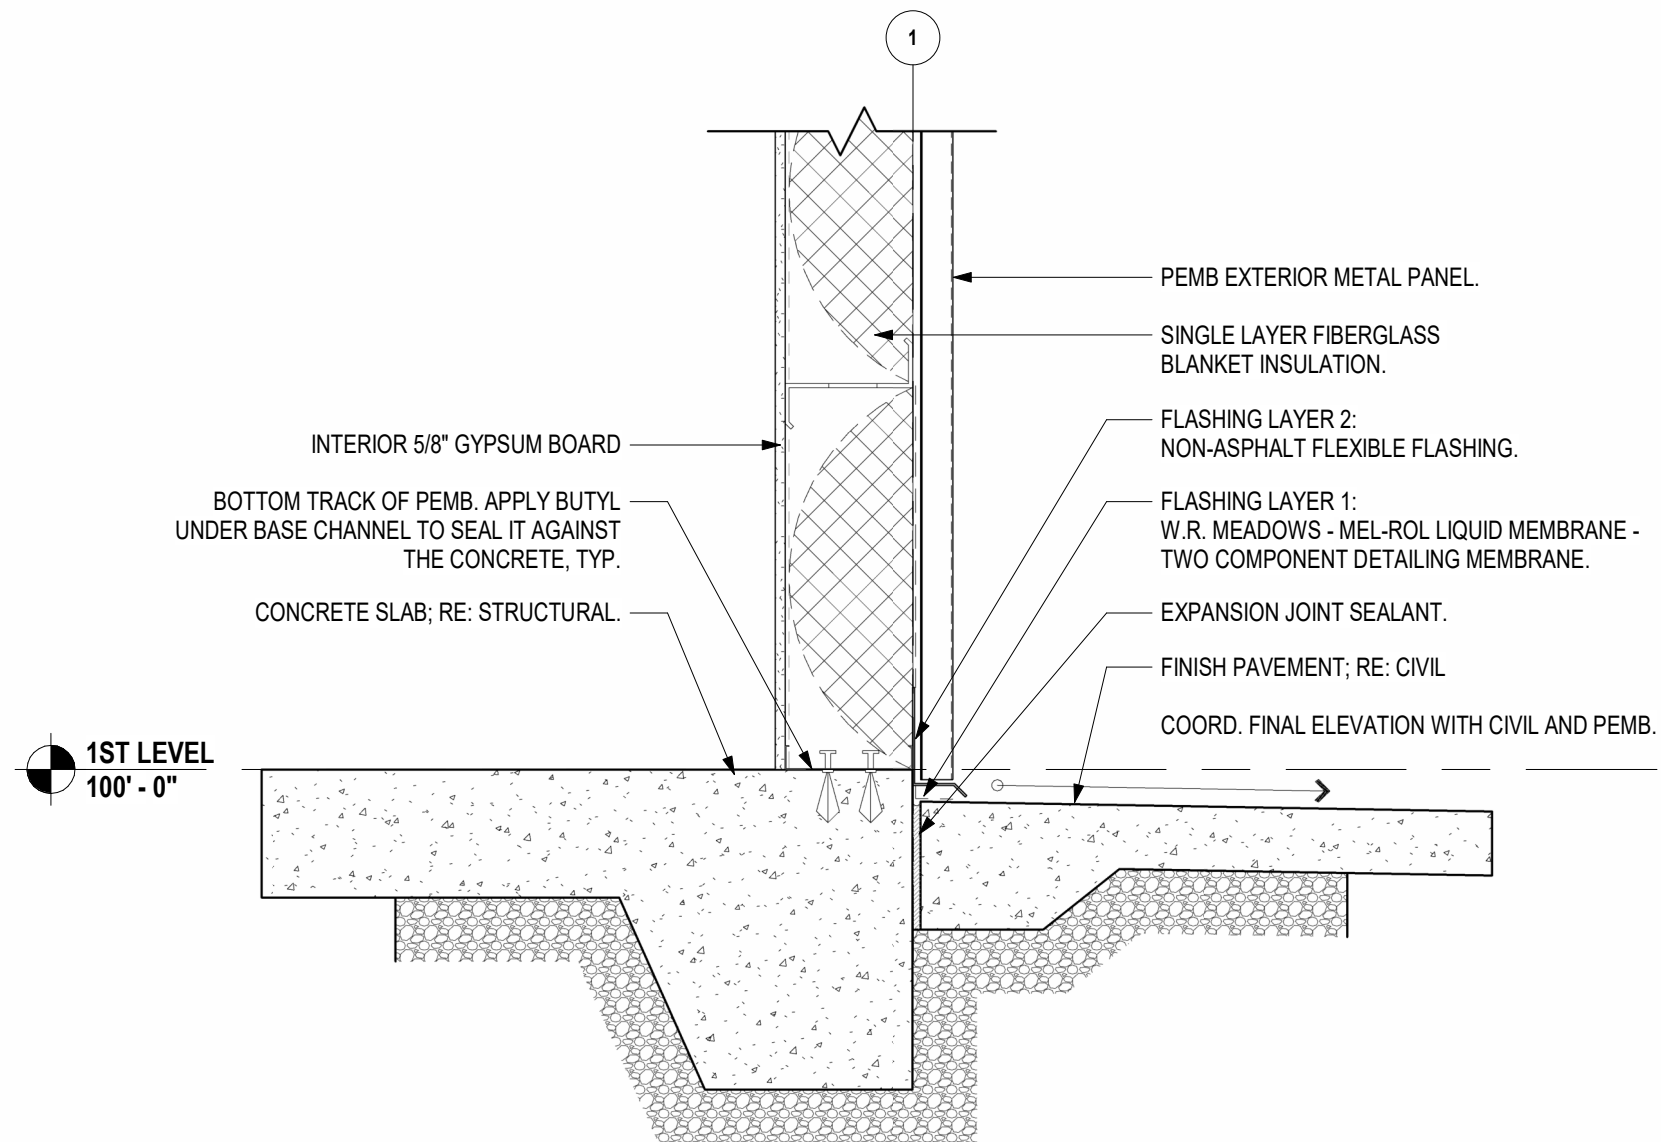

H3 SECTION - PEMB WALL BASE  
1" = 1'-0"


GENERAL NOTES:  
REFLECTED CEILING PLANS

- RE: SHEET G001 FOR ADDITIONAL GENERAL NOTES THAT ARE APPLICABLE.
- RE: DETAILS FOR ADDITIONAL CONDITIONS AND CEILING HEIGHT INFORMATION.
- RE: FINISH LEGEND AND FINISH SCHEDULE FOR ROOM CEILING FINISHES.
- RE: INTERIOR ELEVATIONS FOR LOCATION OF WALL MOUNTED LIGHT FIXTURES.
- RE: ELECTRICAL SHEETS AND SPECIFICATIONS FOR DETAILED INFORMATION ON LIGHT FIXTURE SCHEDULE.
- RE: MECHANICAL SHEETS AND SPECIFICATIONS FOR DETAILED INFORMATION ON DIFFUSERS.
- RE: MECHANICAL SHEETS FOR LOCATIONS OF SOUND ISOLATION BELOW AND OR AROUND MECH. EQUIPMENT.
- DIMENSIONS SHOWN ON THE REFLECTED CEILING PLANS ARE TO THE FACE OF GYP. BOARD (F.G.) AND COLUMN GRID LINES, UNLESS NOTED OR SHOWN OTHERWISE.
- ALL CEILINGS TO BE 9'-0" A.F.F., UNLESS NOTED OTHERWISE.
- ALL CEILING HEIGHTS AS SHOWN ON PLANS AND DETAILS ARE FROM SLAB OR TILE FLOOR (FINISHED FLOOR) TO FINISH CEILING.
- AT ALL GYP. BD. SOFFITS EXTEND GYP. BD. UP 6 INCHES ABOVE ADJACENT CEILING.
- CEILING TILES/GRID TO BE CENTERED IN THE ROOM, UNLESS NOTED OTHERWISE.
- RECESSED LIGHTING, SPEAKERS, SMOKE DETECTORS, ETC. AND PENDANT LIGHT FIXTURES - SHALL BE CENTERED IN CEILING TILE OR GYP. BD. CEILING, UNLESS NOTED OTHERWISE.
- COORDINATE ALL PENDANT MOUNTED LIGHT FIXTURES IN EQUIPMENT AREAS WITH EXPOSED STRUCTURE.
- COORDINATE ALL CEILING MOUNTED EQUIPMENT WITH CASEWORK BELOW.
- IF THERE IS A CONFLICT BETWEEN ANY ABOVE-CEILING MECHANICAL / ELECTRICAL / PLUMBING WORK & THE SCHEDULED OR SHOWN CEILING HEIGHT, CONTACT THE ARCHITECT IMMEDIATELY FOR CLARIFICATION.
- PROVIDE OVERALL CEILING COORDINATION DRAWING SHOWING ALL DEVICES DURING SHOP SUBMITTAL PROCESS.
- ALL LIGHTING BY G.C. COORD. WITH MILLWORK CONTRACTOR FOR LOCATION.
- ALL EXPOSED CONDUIT, DUCTWORK, ETC. TO BE PAINTED BLACK, TYP.

CEILING PLAN  
LEGEND & SYMBOLS

NOTE  
SOME SYMBOLS MAY NOT BE USED IN THIS DRAWING OR PROJECT.

| GYPSUM BD.  |                                                                               |
|-------------|-------------------------------------------------------------------------------|
|             | CONTROL JOINT IN GYP. BD. CEILING                                             |
| ACT-1 VINYL |                                                                               |
|             | SUSPENDED LAY-IN SCRUBABLE CEILING TILE AND EXPOSED TEE-GRID SYSTEM (2'X4')   |
|             | RECESSED DOWNLIGHT LED LIGHT FIXTURE; RE: ELECT. DRAWINGS FOR TYPE.           |
|             | RECESSED LED DIRECTIONAL LIGHT FIXTURE; RE: ELECT. DRAWINGS FOR TYPE.         |
|             | SURFACE MOUNTED LED LIGHT FIXTURE; RE: ELECT. DRAWINGS FOR TYPE.              |
|             | SUSPENDED DIRECT/INDIRECT LED LIGHT FIXTURE; RE: ELECT. DRAWINGS FOR TYPE.    |
|             | LED STRIP LIGHT FIXTURE; RE: ELECT. DRAWINGS FOR TYPE.                        |
|             | WALL MOUNTED LIGHT FIXTURE; RE: ELECT. DRAWINGS FOR TYPE.                     |
|             | EMERGENCY WALL MOUNTED LIGHT FIXTURE; RE: ELECT. DRAWINGS FOR TYPE.           |
|             | EMERGENCY EXIT LIGHT FIXTURE (CEILING MOUNTED); RE: ELECT. DRAWINGS FOR TYPE. |
|             | EMERGENCY EXIT LIGHT FIXTURE (WALL MOUNTED); RE: ELECT. DRAWINGS FOR TYPE.    |
|             | CEILING MOUNTED RETURN AIR GRILLE; RE: MECH. DRAWINGS FOR TYPE.               |
|             | CEILING MOUNTED SUPPLY DIFFUSER; RE: MECH. DRAWINGS FOR TYPE.                 |
|             | EXHAUST FAN / GRILLE; RE: MECH. DRAWINGS FOR TYPE.                            |
|             | EXHAUST DUCT; RE: MECH. DRAWINGS FOR TYPE.                                    |
|             | CEILING MOUNTED SPEAKER GRILLE; RE: ELECT. DRAWINGS FOR TYPE.                 |
|             | CEILING HEIGHT SYMBOL.                                                        |

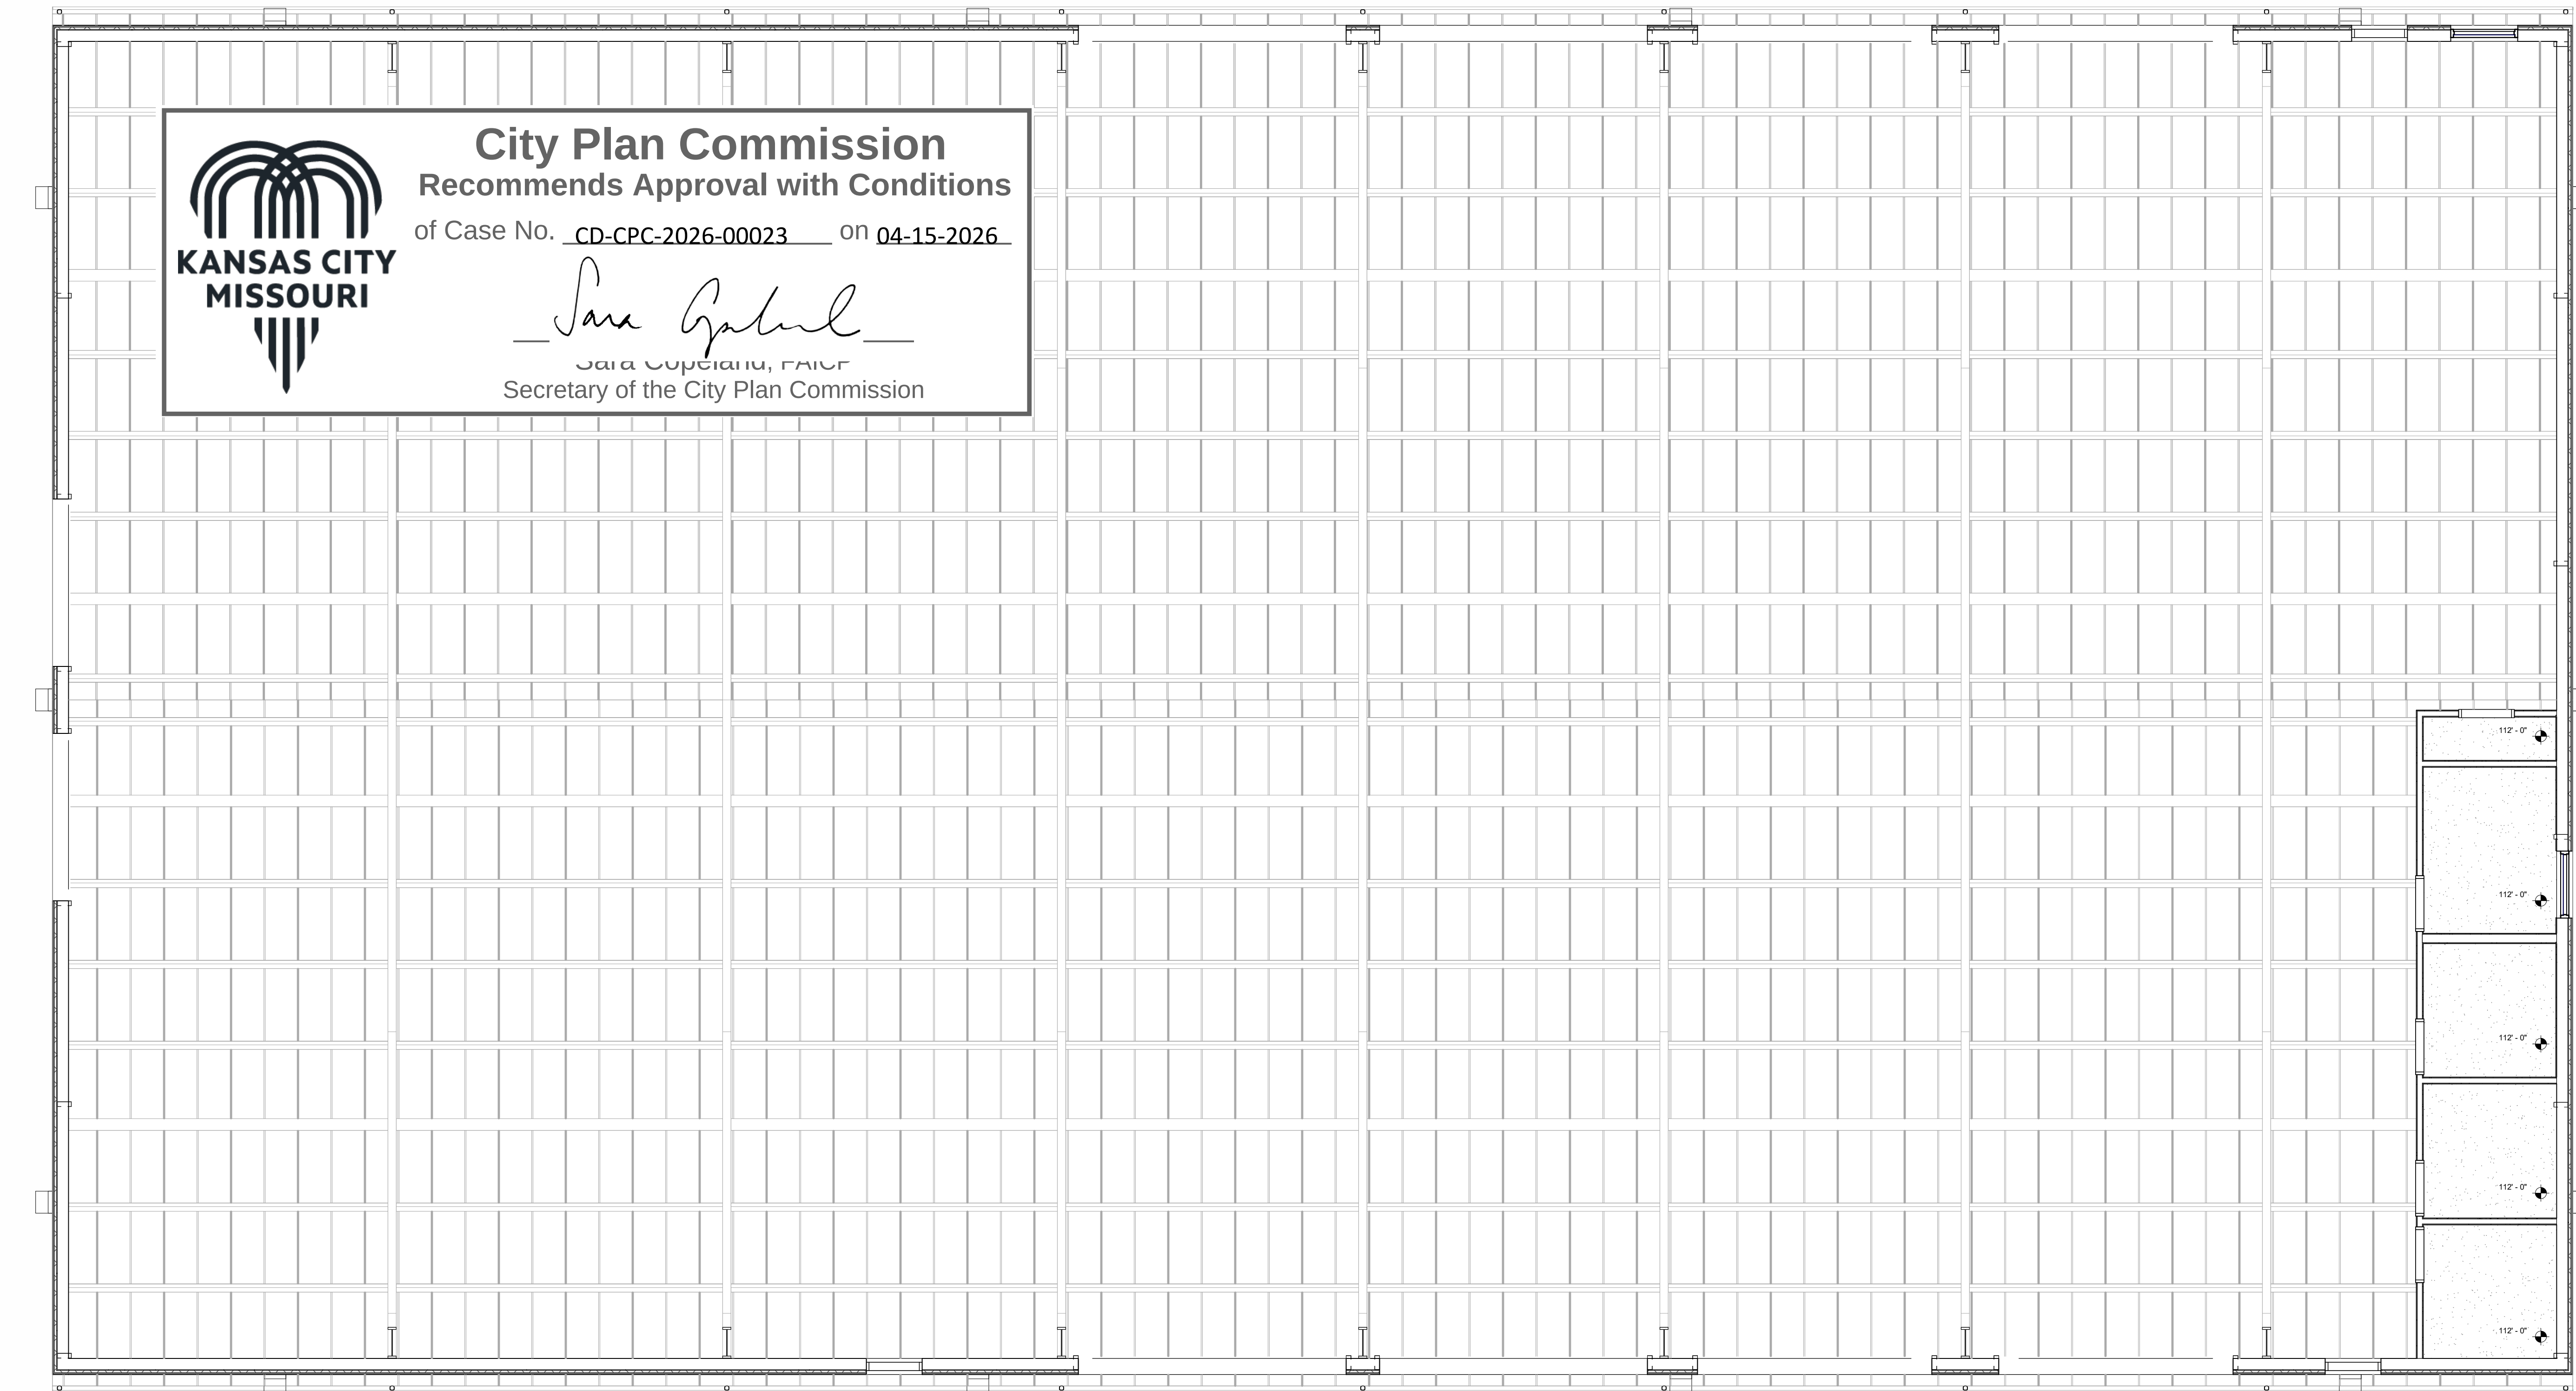

A11 1ST FLOOR - REFLECTED CEILING PLAN  
3/16" = 1'-0"

VS SERVICES - WAREHOUSE

5019 RAYTOWN RD  
KANSAS CITY, MISSOURI 64133

COPYRIGHT © BY  
COLLINS | WEBB  
ARCHITECTURE, LLC

REVISION DATES:

NOT FOR  
CONSTRUCTION

PROFESSIONAL SEAL

A102

ISSUE DATE: 23 FEBRUARY 2026  
COLLINS WEBB #: 26029

REFLECTED CEILING PLAN AND  
DETAILS

collins | webb  
ARCHITECTURE

307A SW Market St., Lees Summit, MO 64033 | 816.269.2270 | www.collinsandwebb.com

DEVELOPMENT PLAN SUBMITTAL



City Plan Commission  
Recommends Approval with Conditions

of Case No. CD-CPC-2026-00023 on 04-15-2026


*Sara Cooper*  
Sara Cooper, FAICP  
Secretary of the City Plan Commission

GENERAL NOTES:  
ROOF PLANS


1. RE-SHEET G001 FOR ADDITIONAL GENERAL NOTES THAT ARE APPLICABLE.
2. DIMENSIONS SHOWN ON THE ROOF PLAN ARE TO THE FACE OF EXTERIOR WALL, FACE OF MASONRY (FOM), FACE OF CONCRETE WALLS (FOC), AND COLUMN GRID LINES, UNLESS NOTED OR SHOWN OTHERWISE.
3. PROVIDE 1/2" TAPERED INSULATION AT ALL ROOF CURBS AND AT EQUIPMENT WHICH EXCEEDS 18 INCHES IN WIDTH.

ROOF PLAN LEGEND

- SLOPE DIRECTION
- TAPERED INSULATION CRICKET OVERBUILD
- ROOF WALKING PAD
- ROOF DRAIN

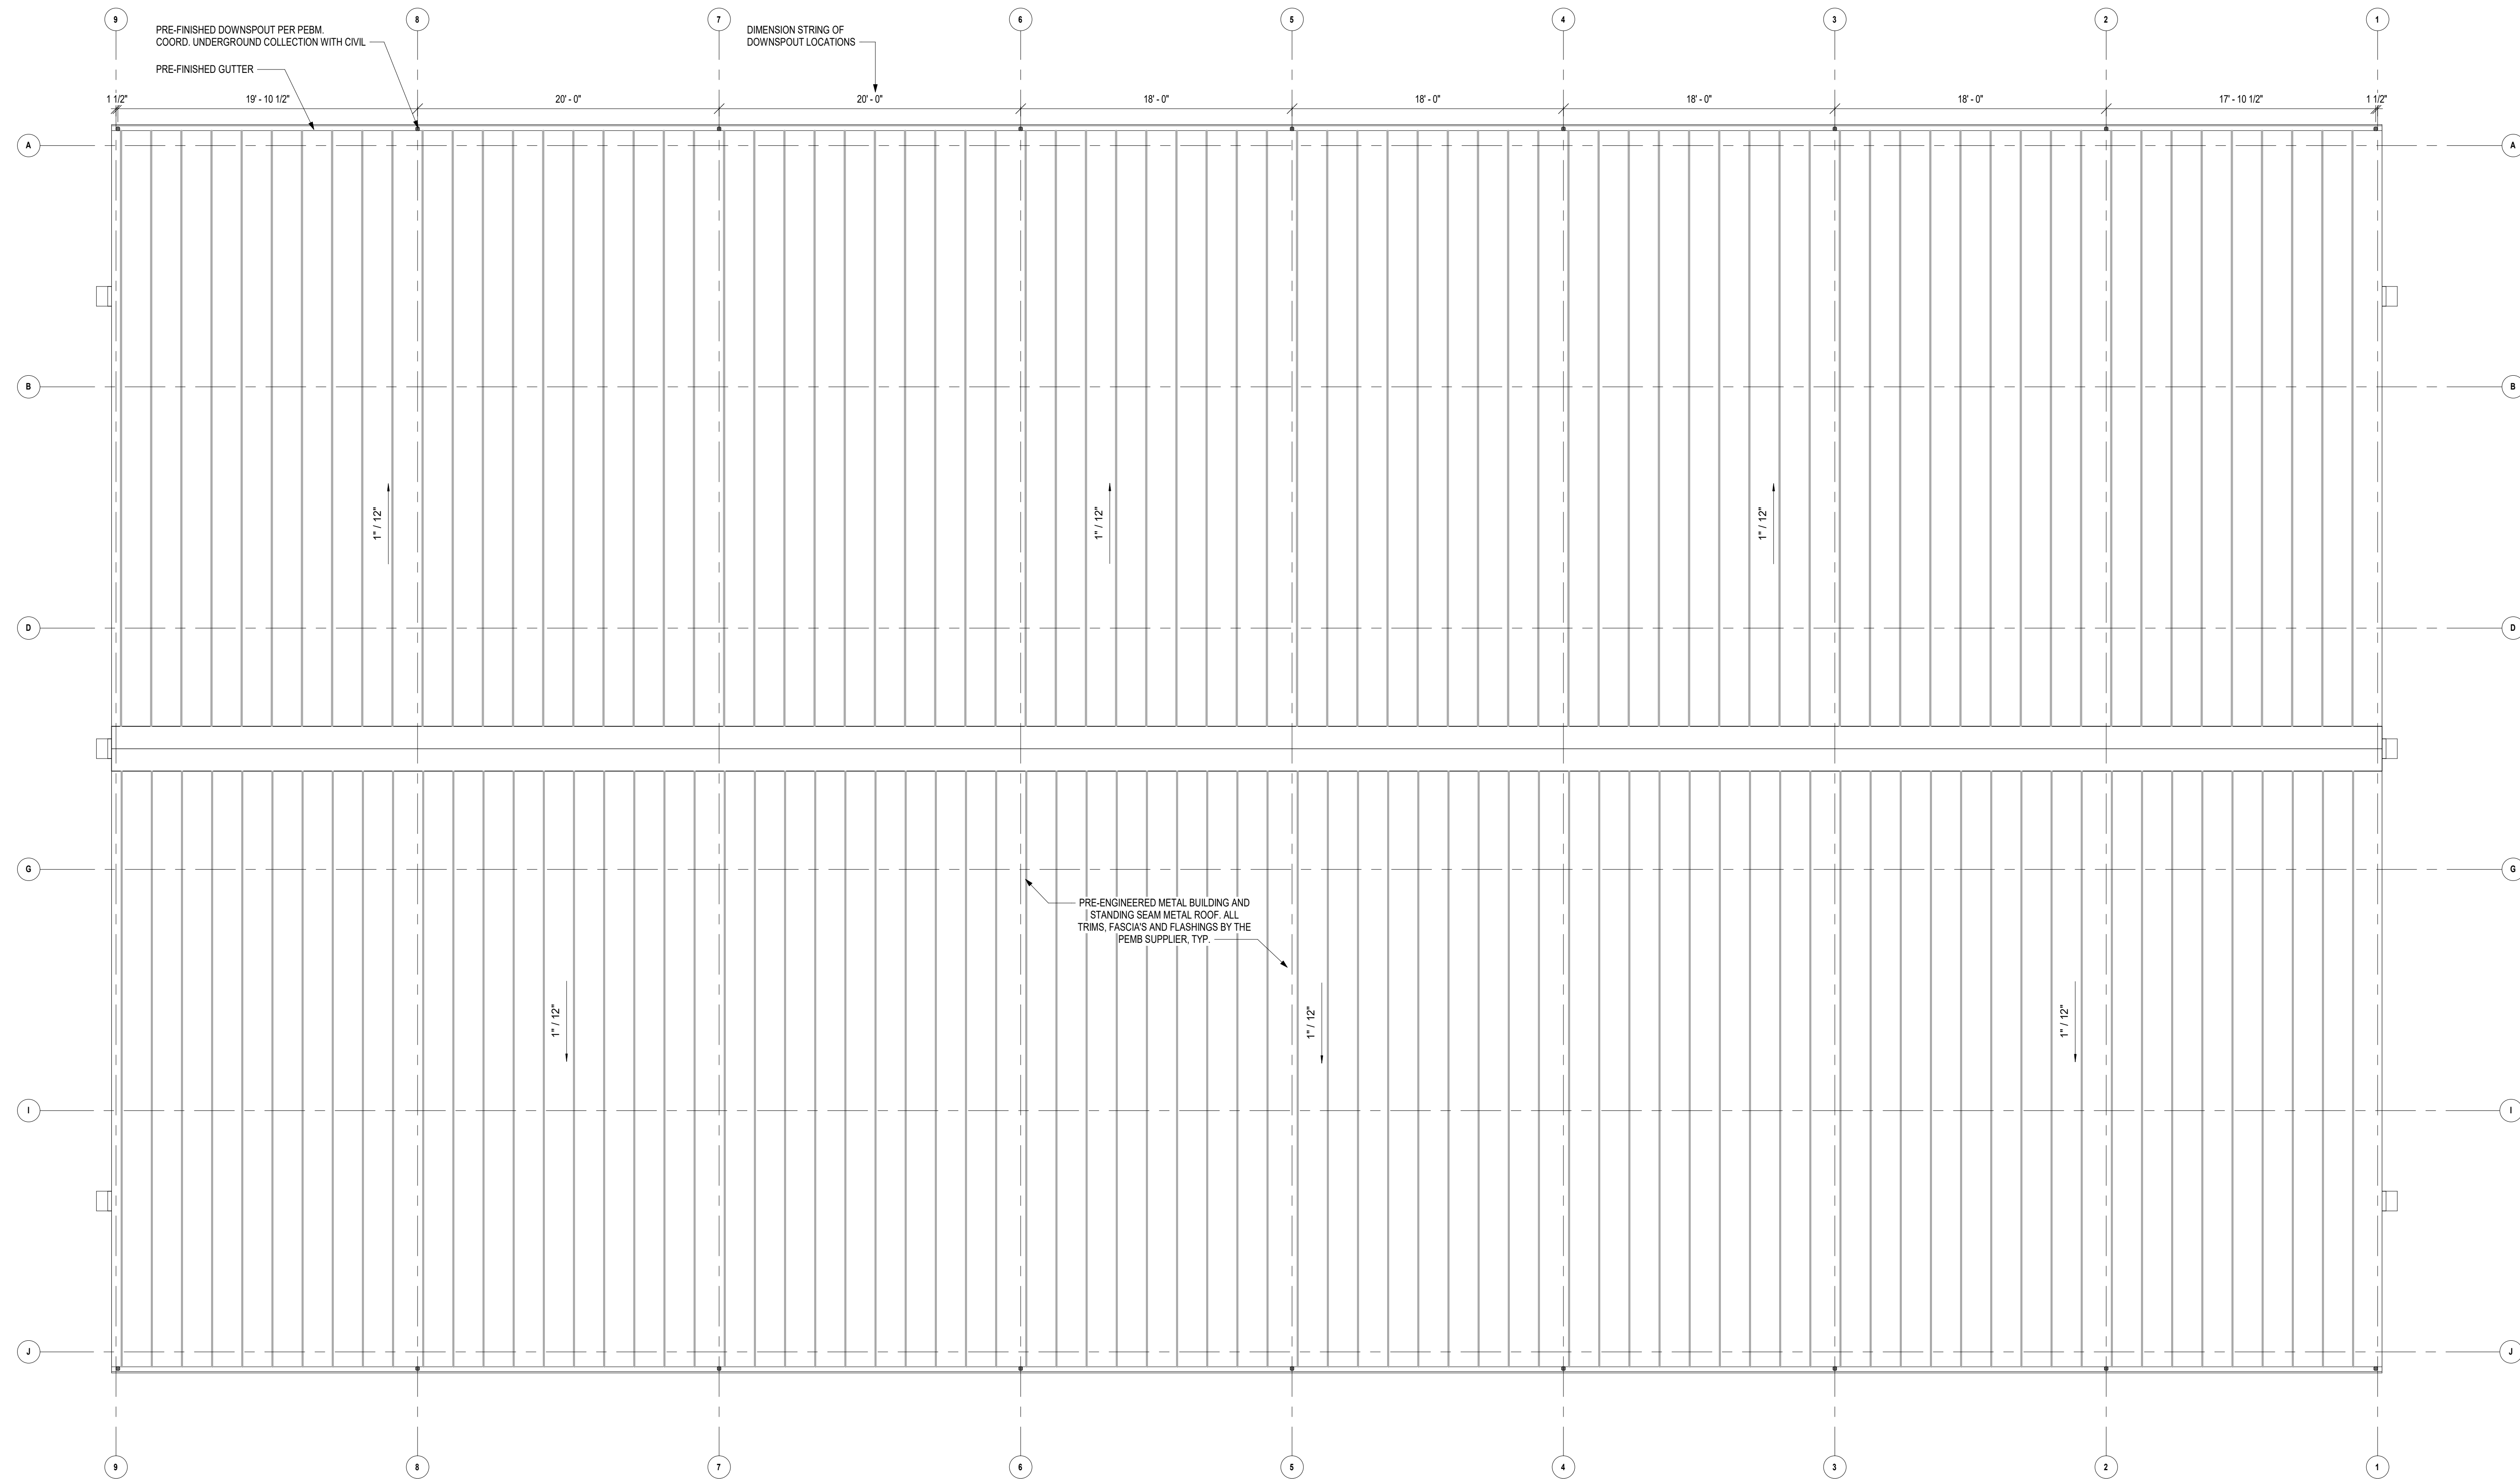

A12 ROOF PLAN  
3/16" = 1'-0"

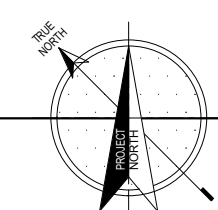

VS SERVICES - WAREHOUSE

5019 RAYTOWN RD  
KANSAS CITY, MISSOURI 64133

COPYRIGHT © BY  
COLLINS | WEBB  
ARCHITECTURE, LLC

REVISION DATES:

NOT FOR  
CONSTRUCTION

PROFESSIONAL SEAL

A104

ISSUE DATE: 23 FEBRUARY 2026  
COLLINS WEBB #: 26029


ROOF PLAN

307A SW Market St., Lees Summit, MO 64083 | 816.249.2270 | www.collinsandwebb.com


DEVELOPMENT PLAN SUBMITTAL




**City Plan Commission**  
**Recommends Approval with Conditions**  
of Case No. CD-CPC-2026-00023 on 04-15-2026  
*Sara Copeland*  
Sara Copeland, FAICP  
Secretary of the City Plan Commission

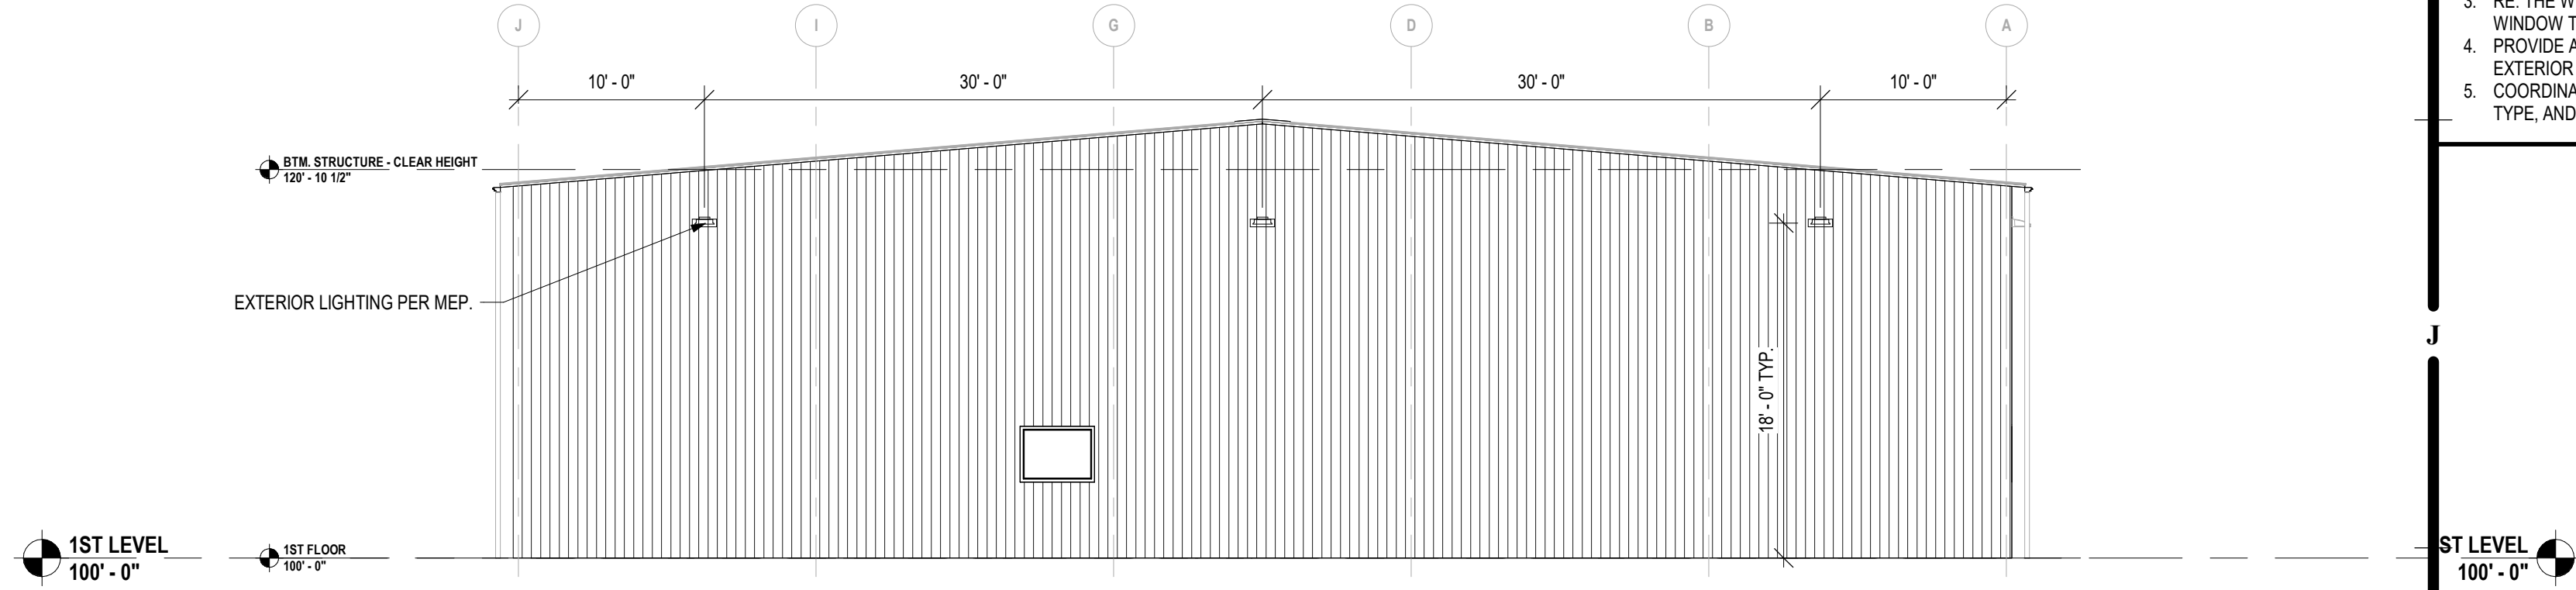


**H5 SOUTHEAST ELEVATION**  
1/8" = 1'-0"

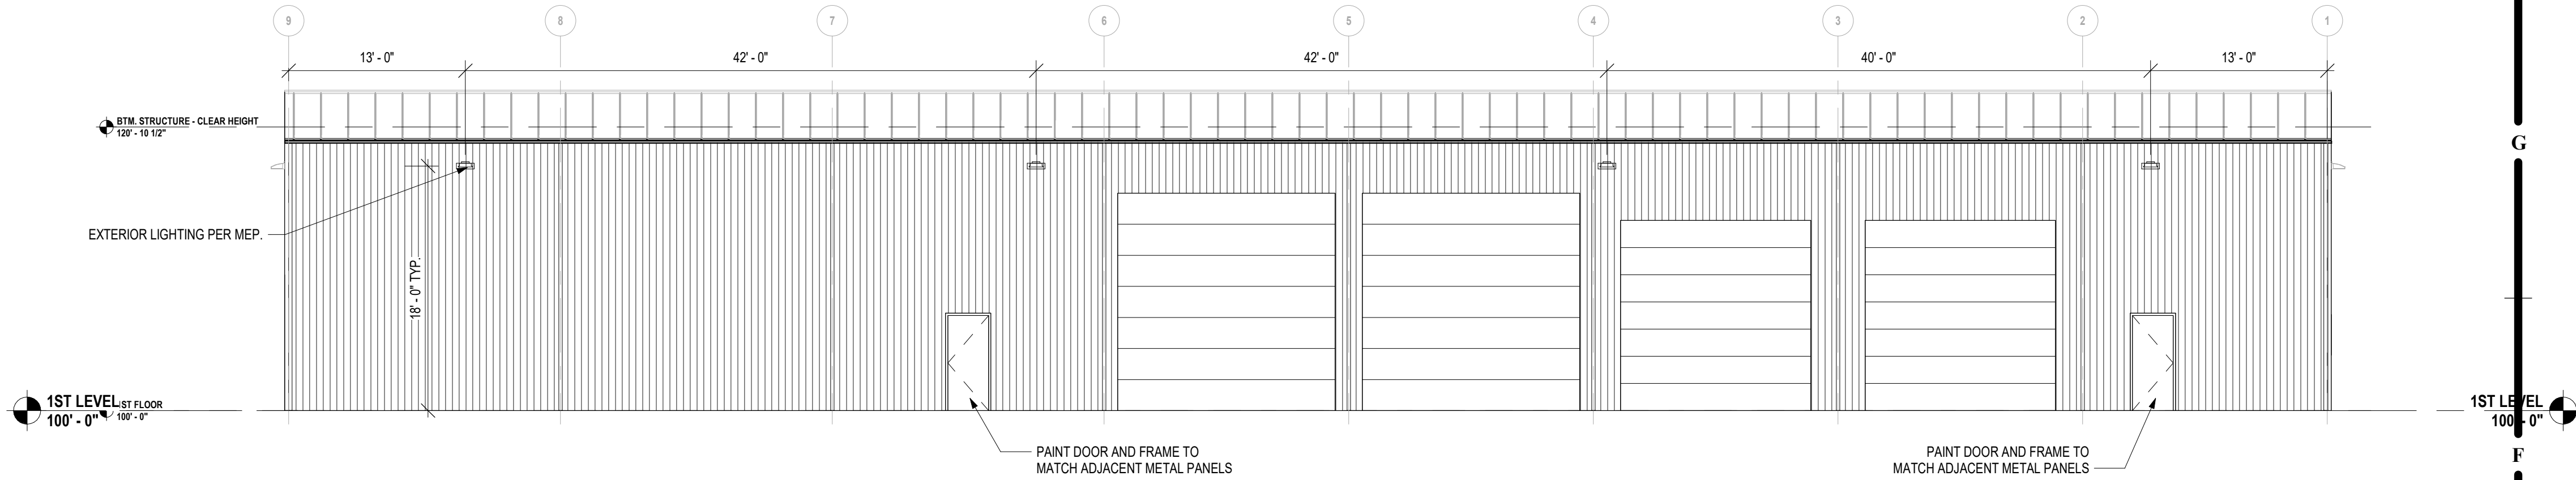

**F8 SOUTHWEST ELEVATION**  
1/8" = 1'-0"

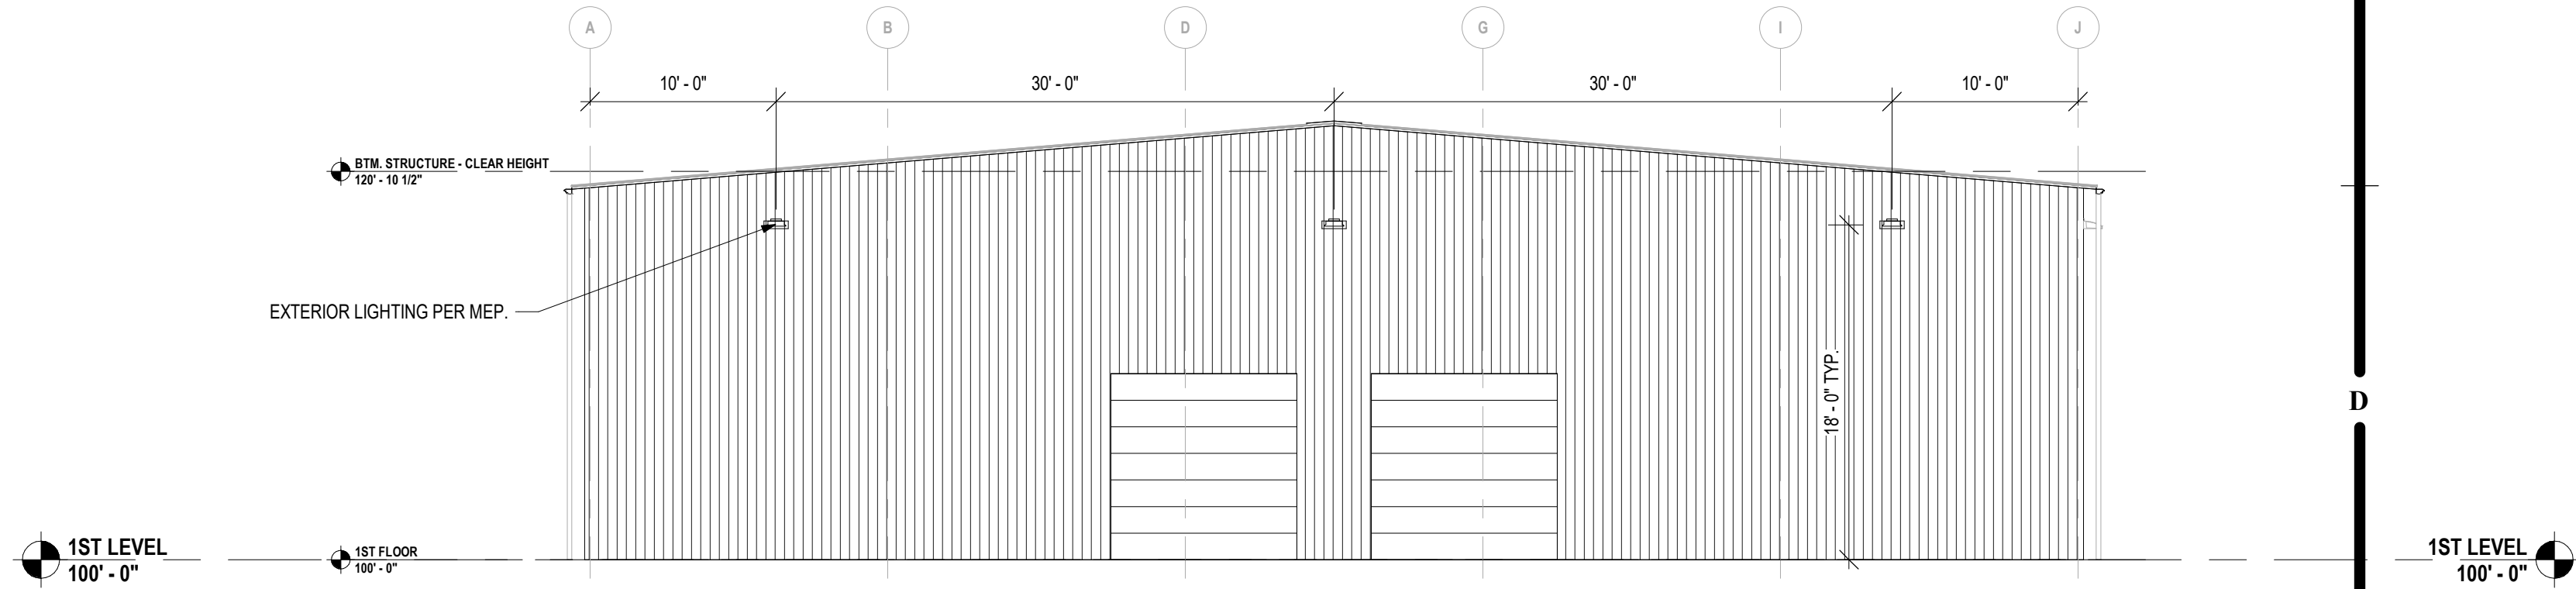

**D5 NORTHWEST ELEVATION**  
1/8" = 1'-0"

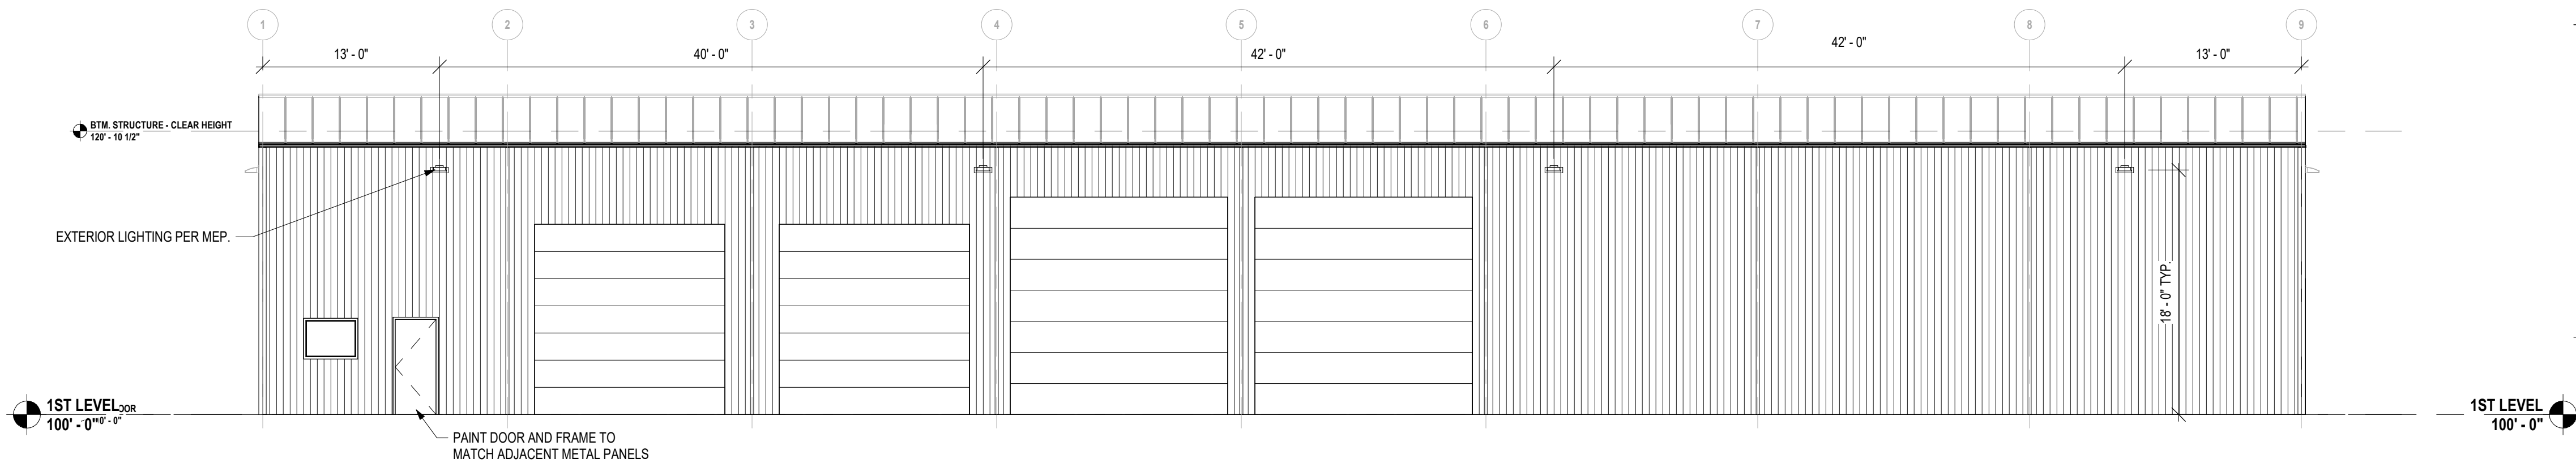

**A8 NORTHEAST ELEVATION**  
1/8" = 1'-0"

**GENERAL NOTES:  
EXTERIOR ELEVATIONS**

1. RE: SHEET G001 FOR ADDITIONAL GENERAL NOTES THAT ARE APPLICABLE.
2. DIMENSIONS SHOWN ON THE EXTERIOR ELEVATIONS ARE TO THE FACE OF EXTERIOR WALL, FACE OF MASONRY (FOM), FACE OF CONCRETE WALLS (FCO), FACE OF STUD, AND COLUMN GRID LINES, UNLESS OTHERWISE NOTED OR INDICATED.
3. RE: THE WINDOW TYPES SHEET FOR ALL EXTERIOR WINDOW TYPES AND GLASS TYPES.
4. PROVIDE ALL BLOCKING AND POWER AS REQUIRED FOR EXTERIOR SIGNAGE.
5. COORDINATE EXTERIOR WALL PACK LIGHTING, POWER, TYPE, AND SPEC. WITH MEP.

**VS SERVICES - WAREHOUSE**

5019 RAYTOWN RD  
KANSAS CITY, MISSOURI 64133

COPYRIGHT © BY  
COLLINS | WEBB  
ARCHITECTURE, LLC

REVISION DATES:

**NOT FOR  
CONSTRUCTION**

PROFESSIONAL SEAL

**A201**

ISSUE DATE: 23 FEBRUARY 2026  
COLLINS WEBB #: 26029

**EXTERIOR ELEVATIONS**

DEVELOPMENT PLAN SUBMITTAL





**KANSAS CITY  
MISSOURI**


# City Plan Commission

## Recommends Approval with Conditions

of Case No. CD-CPC-2026-00023 on 04-15-2026



Sara Copeland, FAICP  
Secretary of the City Plan Commission

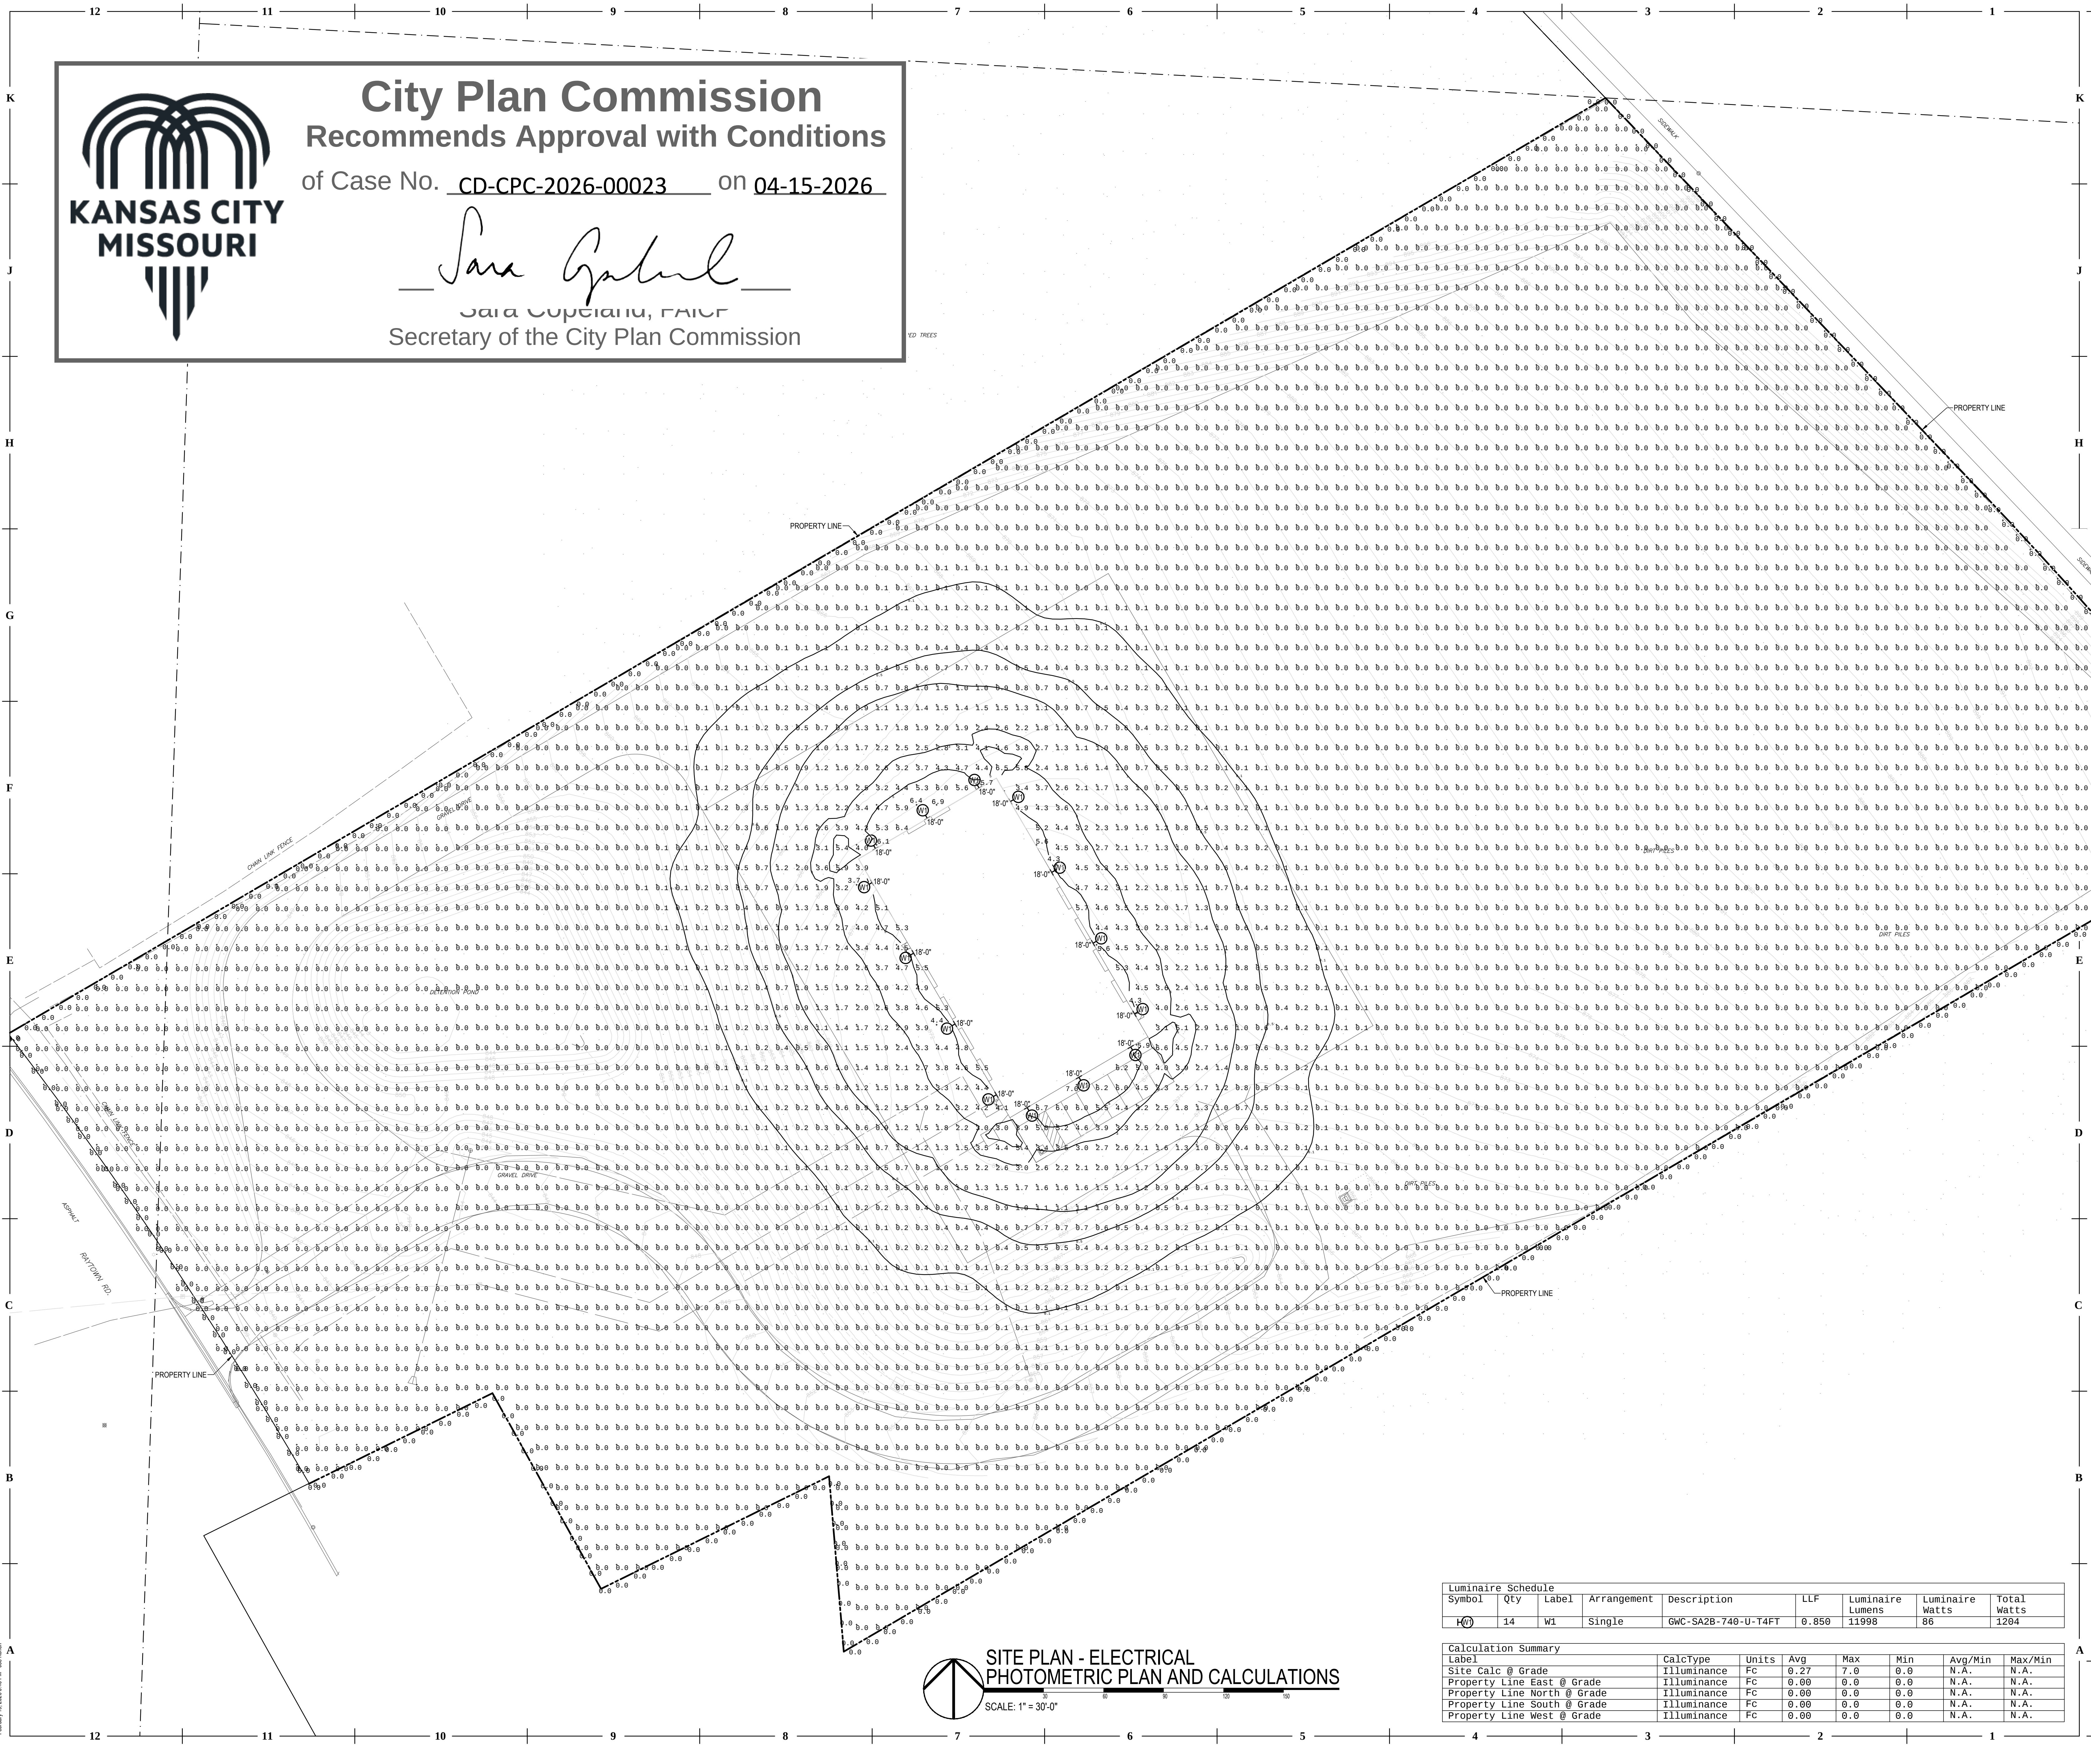

**SITE PLAN - ELECTRICAL  
PHOTOMETRIC PLAN AND CALCULATIONS**

SCALE: 1" = 30'-0"

| Luminaire Schedule |     |       |             |                     |       |                  |                 |             |
|--------------------|-----|-------|-------------|---------------------|-------|------------------|-----------------|-------------|
| Symbol             | Qty | Label | Arrangement | Description         | LLF   | Luminaire Lumens | Luminaire Watts | Total Watts |
| (H)                | 14  | W1    | Single      | GWC-SA28-748-U-T4FT | 0.850 | 11998            | 86              | 1284        |

| Calculation Summary         |             |       |      |     |     |         |         |
|-----------------------------|-------------|-------|------|-----|-----|---------|---------|
| Label                       | CalcType    | Units | Avg  | Max | Min | Avg/Min | Max/Min |
| Site Calc @ Grade           | Illuminance | FC    | 0.27 | 7.0 | 0.0 | N.A.    | N.A.    |
| Property Line East @ Grade  | Illuminance | FC    | 0.00 | 0.0 | 0.0 | N.A.    | N.A.    |
| Property Line North @ Grade | Illuminance | FC    | 0.00 | 0.0 | 0.0 | N.A.    | N.A.    |
| Property Line South @ Grade | Illuminance | FC    | 0.00 | 0.0 | 0.0 | N.A.    | N.A.    |
| Property Line West @ Grade  | Illuminance | FC    | 0.00 | 0.0 | 0.0 | N.A.    | N.A.    |

© COPYRIGHT 2026  
Permission to reproduce all or part of this drawing is hereby granted solely for the limited purpose of construction of this project or archiving. Unauthorized copying, disclosure or construction use without written permission of Alvine is prohibited by copyright law.

NOTE:  
DO NOT SCALE DRAWINGS. VERIFY ALL DIMENSIONS and clearances from ARCHITECTURAL, STRUCTURAL, and other appropriate drawing or at site. Lay out and coordinate all work prior to installation to provide clearances required for operation, maintenance, and codes and verify non-interference with other work. DO NOT FABRICATE PRIOR TO VERIFICATION OF CLEARANCE FOR ALL TRADES. READ SPECIFICATIONS.



**NOT FOR  
CONSTRUCTION**

PROFESSIONAL SEAL  
**E001**  
ISSUE DATE: 23 FEBRUARY 2026  
COLLINS WEBB #: 26029

**SITE PLAN - ELECTRICAL  
PHOTOMETRIC PLAN AND CALCS**

**VS SERVICES - WAREHOUSE**  
5019 RAYTOWN RD  
KANSAS CITY, MISSOURI 64133

COPYRIGHT © BY  
COLLINS | WEBB  
ARCHITECTURE, LLC

REVISION DATES:

DEVELOPMENT PLAN SUBMITTAL





City Plan Commission

Recommends Approval with Conditions

of Case No. CD-CPC-2026-00023 on 04-15-2026




Sara Copeland, FAICP  
Secretary of the City Plan Commission





**Record of Public Engagement Meeting for Development Plan for  
5019 Raytown Road CD-CPC-2026-00023**

At 6:00pm on Monday April 06, 2026, MKEC Engineering, Inc. with VS Services hosted a virtual public meeting. No one registered for the meeting. We waited 30 minutes to provide a chance for anyone to register and attend the meeting, and no one attended the meeting. An announcement was made that we were closing the meeting due to no one attending the meeting after 30 minutes.

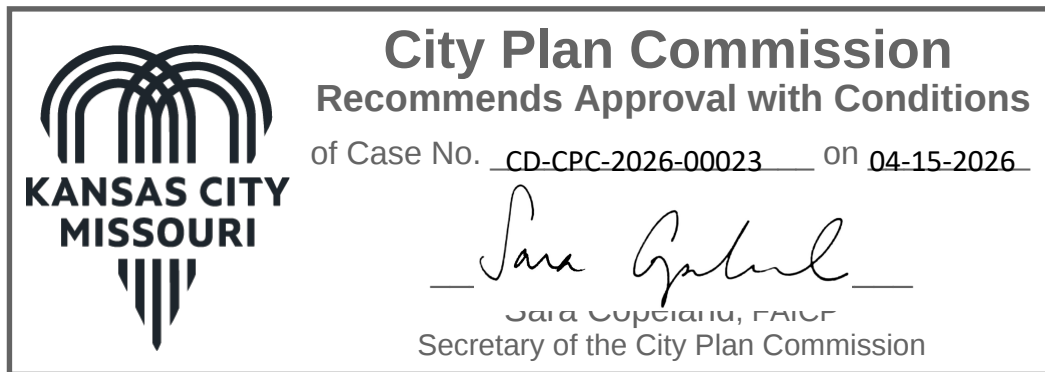




City Plan Commission  
Recommends Approval with Conditions

of Case No. CD-CPC-2026-00023 on 04-15-2026

*Sara Copeland*

Sara Copeland, FAICP  
Secretary of the City Plan Commission

PLAN Alignment - (3)  
PROFILE Alignment - (3)

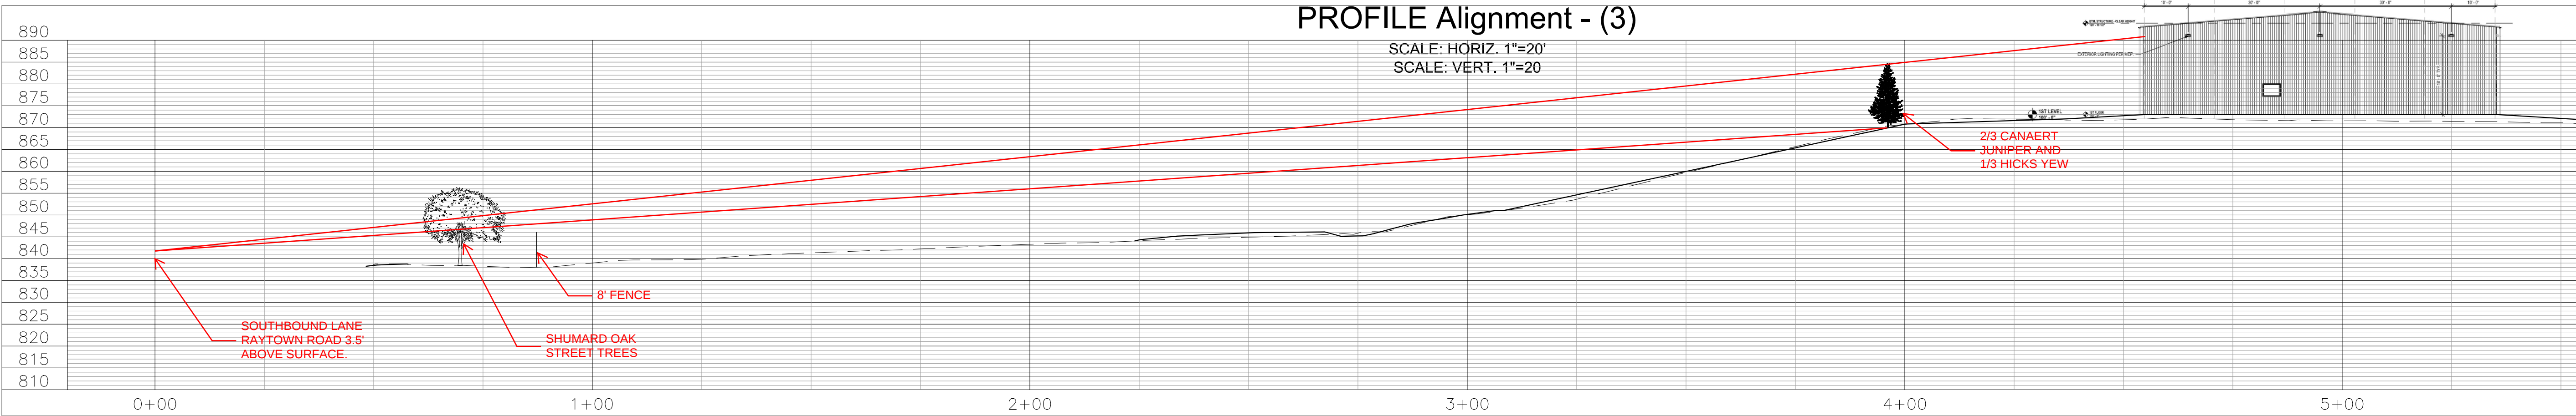


## CHECKLIST SUMMARY

Area Plan Alignment: **Low**

KC Spirit Playbook Alignment: **Low**

CC- Connected City  
DO - Diversity & Opportunity  
HAC- History, Arts & Culture  
HE - Healthy Environment  
PAA - People of All Ages  
POS - Parks & Open Spaces  
SAN - Strong & Accessible Neighborhoods  
SC - Smart City  
SEG - Sustainable & Equitable Growth  
WDC - Well Designed City

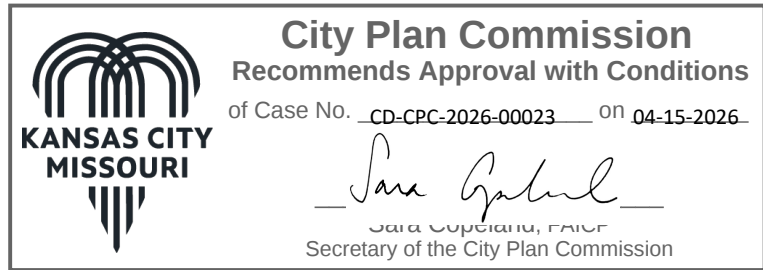

| Evaluation | Goal                              | Notes                                                                                                                                                                                                                                                                                                                                                                                                                                                                                                                                                                                                                                                                                                                                                                                                                                                                                                                                              |
|------------|-----------------------------------|----------------------------------------------------------------------------------------------------------------------------------------------------------------------------------------------------------------------------------------------------------------------------------------------------------------------------------------------------------------------------------------------------------------------------------------------------------------------------------------------------------------------------------------------------------------------------------------------------------------------------------------------------------------------------------------------------------------------------------------------------------------------------------------------------------------------------------------------------------------------------------------------------------------------------------------------------|
| High       |                                   |                                                                                                                                                                                                                                                                                                                                                                                                                                                                                                                                                                                                                                                                                                                                                                                                                                                                                                                                                    |
| Medium     | SEG                               | <b>SEG:</b> The site is within an established area and does not contribute to greenfield development that is outside of where utilities are limited.                                                                                                                                                                                                                                                                                                                                                                                                                                                                                                                                                                                                                                                                                                                                                                                               |
| Low        | CC,<br>HE,<br>POS,<br>SAN,<br>WDC | <b>CC:</b> The site is not providing any sidewalk or sidewalk connections to increase connectivity in the area for other users beside people traveling by car or truck.<br><b>HE:</b> The proposed site provides limited landscaping and can be potentially cut off from access due to the floodplain. Additional landscaping at the rear of the property abutting the Rock Island Trail beyond just grass would increase alignment.<br><b>POS:</b> The site is directly adjacent to the Rock Island Trail and provides minimal screening or landscaping to screen the use.<br><b>WDC:</b> The building façade facing Raytown Road includes minimal transparency and building materials that are of a low quality and do not enhance Raytown Road's status as an image street in the area plan. Alignment would increase with additional transparent windows facing Raytown Road and enhanced building materials for the façade facing the street. |

## Alignment Comments:

The proposed shop and vehicle storage does not enhance the character of Raytown Road as an identified image street in the Blue Ridge Area Plan. The building design does not provide well designed elements, such as windows with two way transparency, nor façade materials that are of a high quality and provide some architectural materials. Alignment would increase with additional windows and the use of materials such as stucco, thin brick, or other materials facing Raytown Road. The minimal landscaping, especially to the rear of the site adjacent to the Rock Island Trail, does not align with the healthy environment or parks and open space goals of the KC Spirit Playbook. The Rock Island Trail is a regional trail that connects to the Katy Trail, and screening and plantings can help transition from the light industrial use to the regionally significant transportation and leisure amenity.

